

**WATERSTONE AT BATON ROUGE
 ASSISTED LIVING & MEMORY CARE**

SIEGEN LANE
 BATON ROUGE, LA 70810


ISSUE: QA
 CONSTRUCTION
 DOCUMENTS

©2016 PI ARCHITECTS, INC.


REVISIONS:

DATE: 03/03/2016
 PROJECT NUMBER: 14017
 SHEET TITLE: TELECOM/SECURITY/AV ELECTRONICS LEVEL 1 FLOOR PLAN (NE)


SHEET: T1.1.1

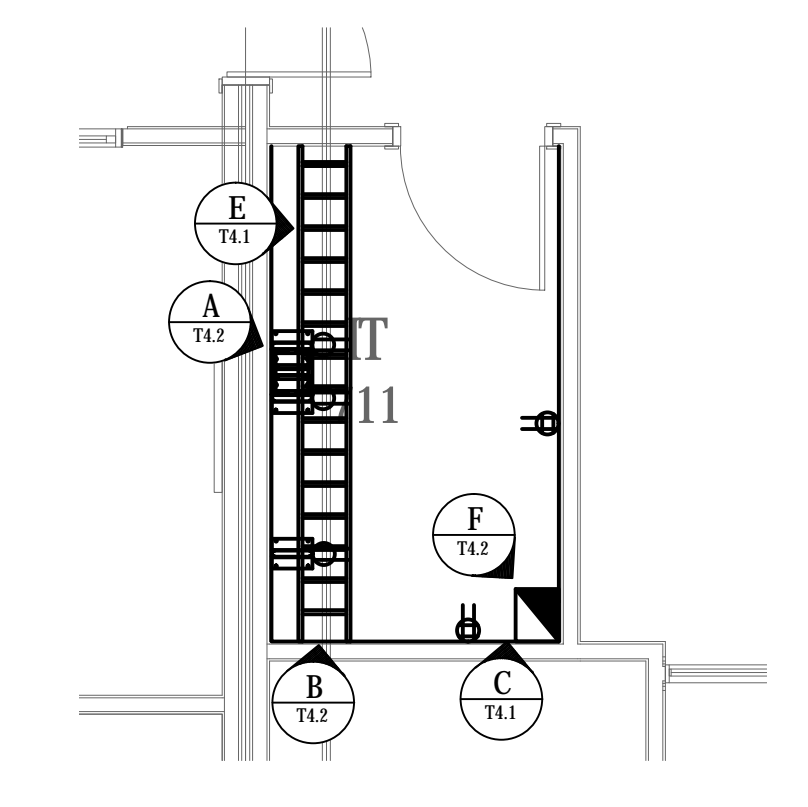

2 ENLARGED IT ROOM #711
 1/4" = 1'-0" 0 2 5 8 FT.

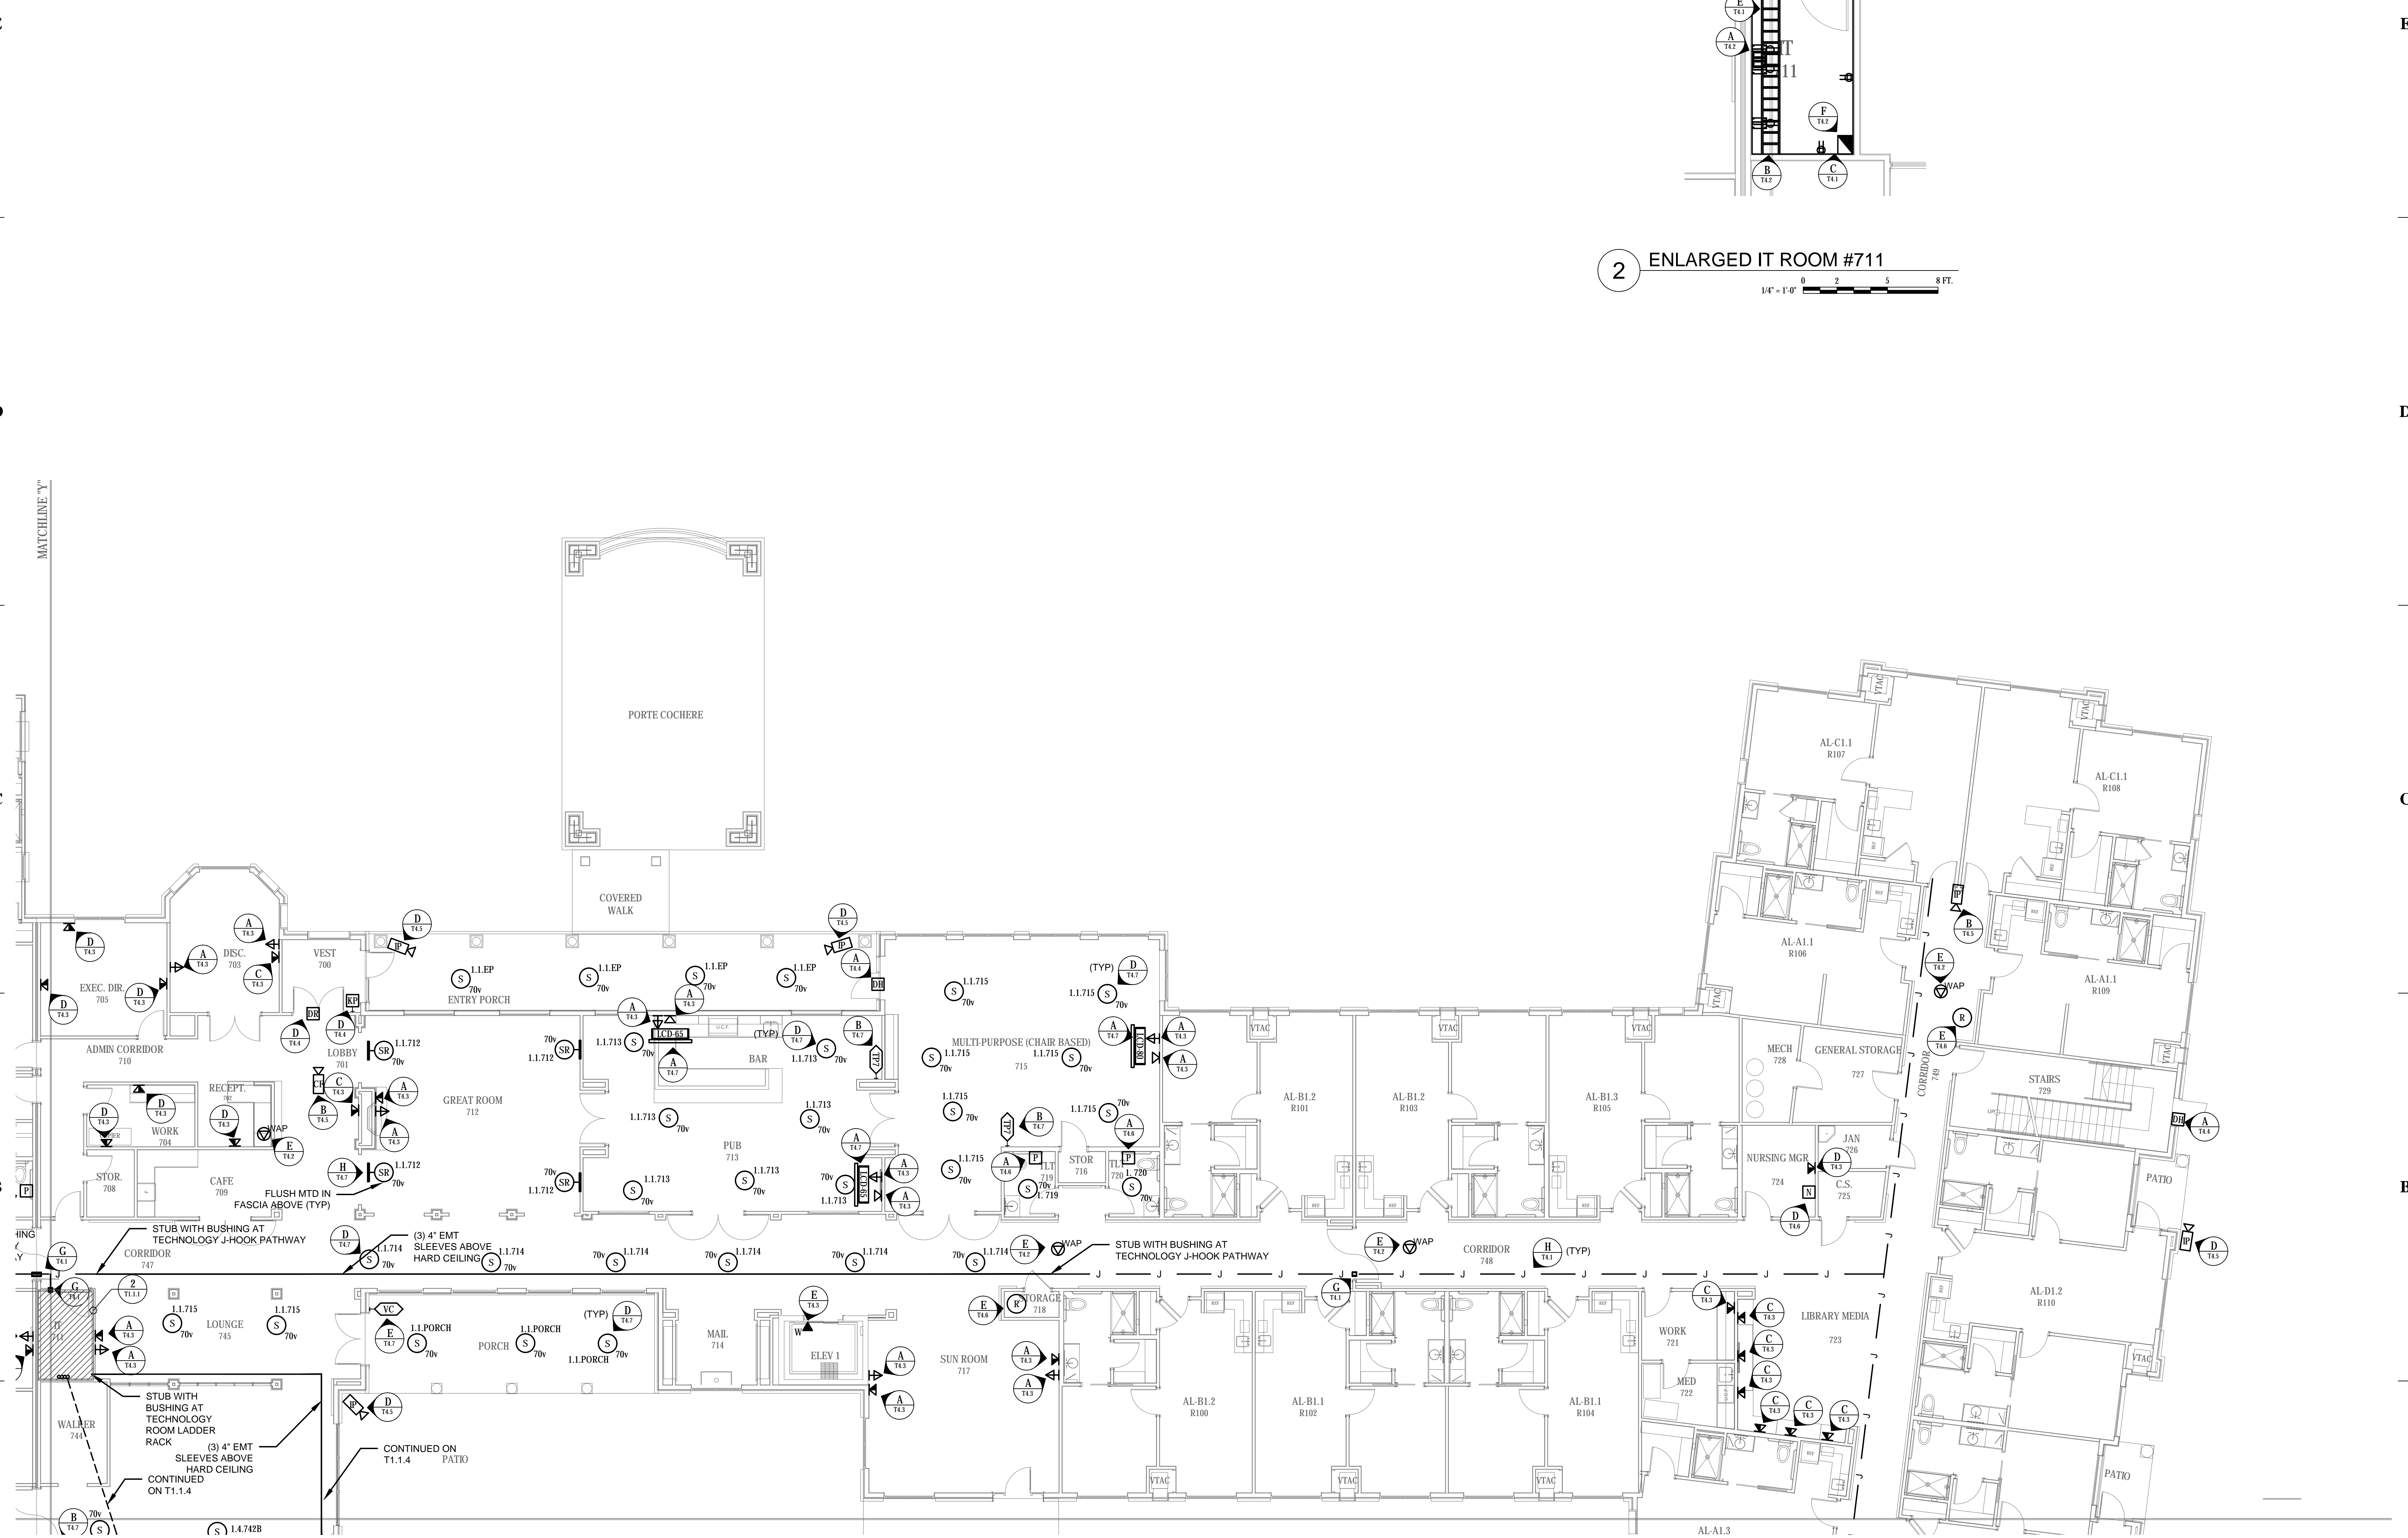

1 TELECOM/SECURITY/AV ELECTRONICS LEVEL 1 FLOOR PLAN (NE)
 1/8" = 1'-0" 0 5 10 15 FT.

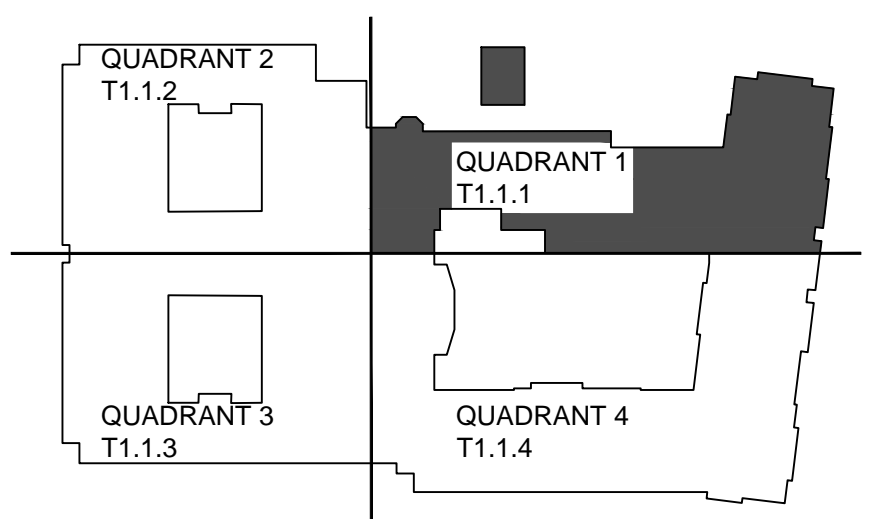

BIM Server: SERVER2015 - BIM Server 19/14017 Concrete/Baton Rouge | Ver. 18.001 | Monday, February 22, 2016 | 3:34 PM