

 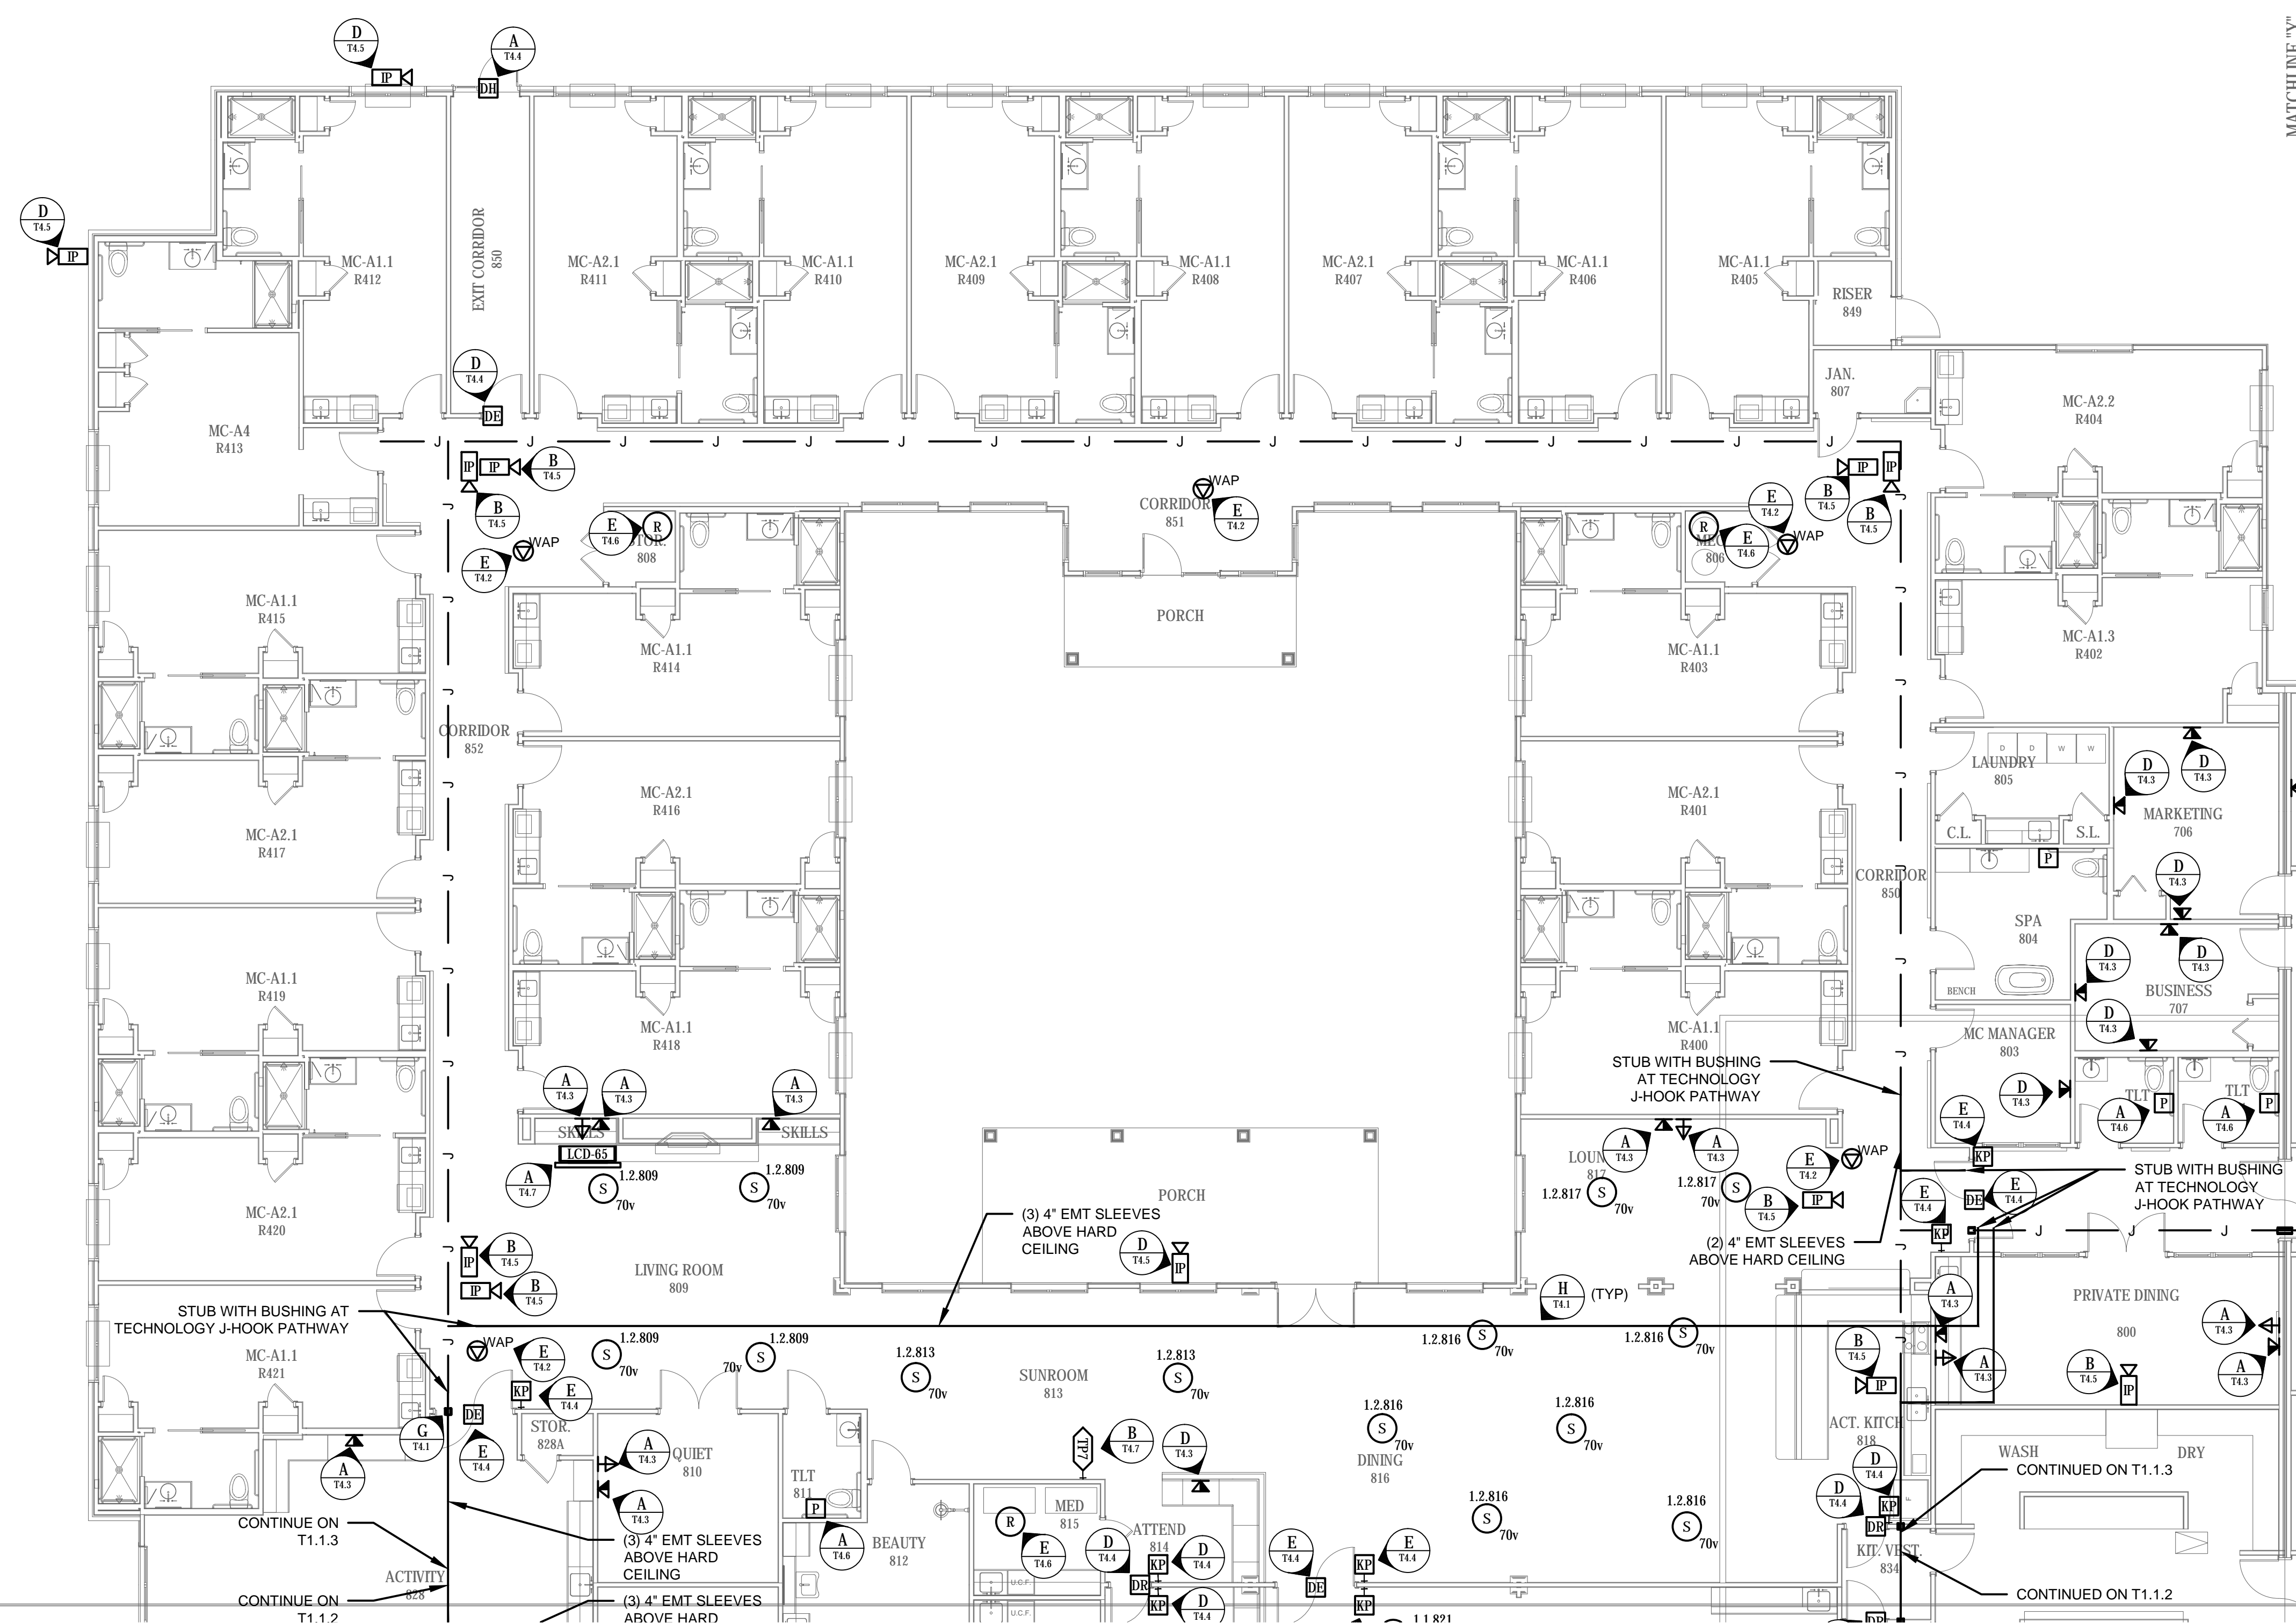


BIM Server: SERVER2016 - BIM Server 181/1017 Concordia Baton Rouge | Ver. 18.001 | Monday, February 22, 2016 | 3:34 PM

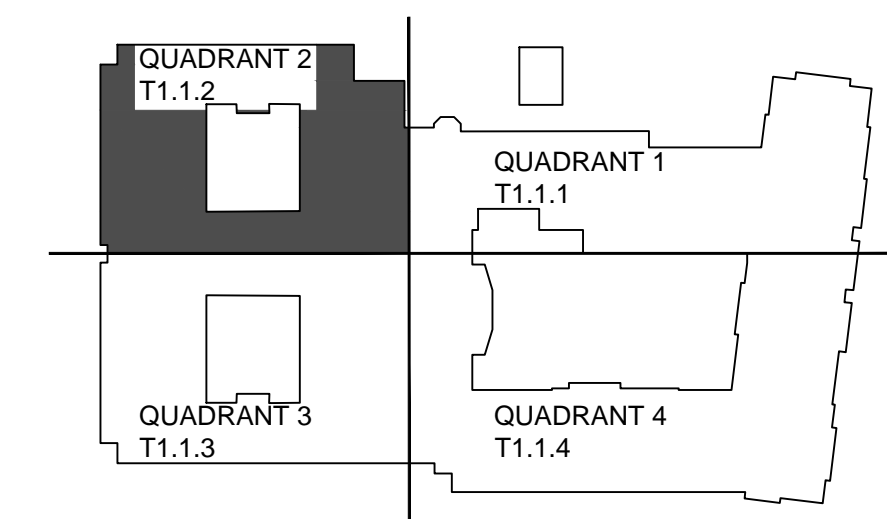

1 TELECOM/SECURITY/AV ELECTRONICS LEVEL 1 FLOOR PLAN (NW)



pi architects
2600 Jefferson St. Suite 303
Austin, TX 78731
P: (512) 231-1910
F: (512) 231-1950
www.piarch.com

architecture + master
interior + landscape
architecture

GUIDEPPOST SOLUTIONS LLC
2800 North Dallas Parkway, Suite 350
Plano, TX 75093
Office: (469) 568-0300
Website: www.guidepostsolutions.com

**WATERSTONE AT BATON ROUGE
ASSISTED LIVING & MEMORY CARE**

SIEGEN LANE
BATON ROUGE, LA 70810

ISSUE: QA
CONSTRUCTION DOCUMENTS

©2016 PI ARCHITECTS, INC.

REVISIONS:

DATE: 03/03/2016
PROJECT NUMBER: 14017
SHEET TITLE: TELECOM/SECURITY/AV ELECTRONICS LEVEL 1 FLOOR PLAN (NW)

SHEET: T1.1.2