

**WATERSTONE AT BATON ROUGE
 ASSISTED LIVING & MEMORY CARE**

SIEGEN LANE
 BATON ROUGE, LA 70810


ISSUE: QA
 CONSTRUCTION
 DOCUMENTS

©2016 PI ARCHITECTS, INC.



REVISIONS:

DATE: 03/03/2016
 PROJECT NUMBER: 14017
 SHEET TITLE: TELECOM/SECURITY/AV ELECTRONICS LEVEL 1 FLOOR PLAN (SW)

SHEET: T1.1.3

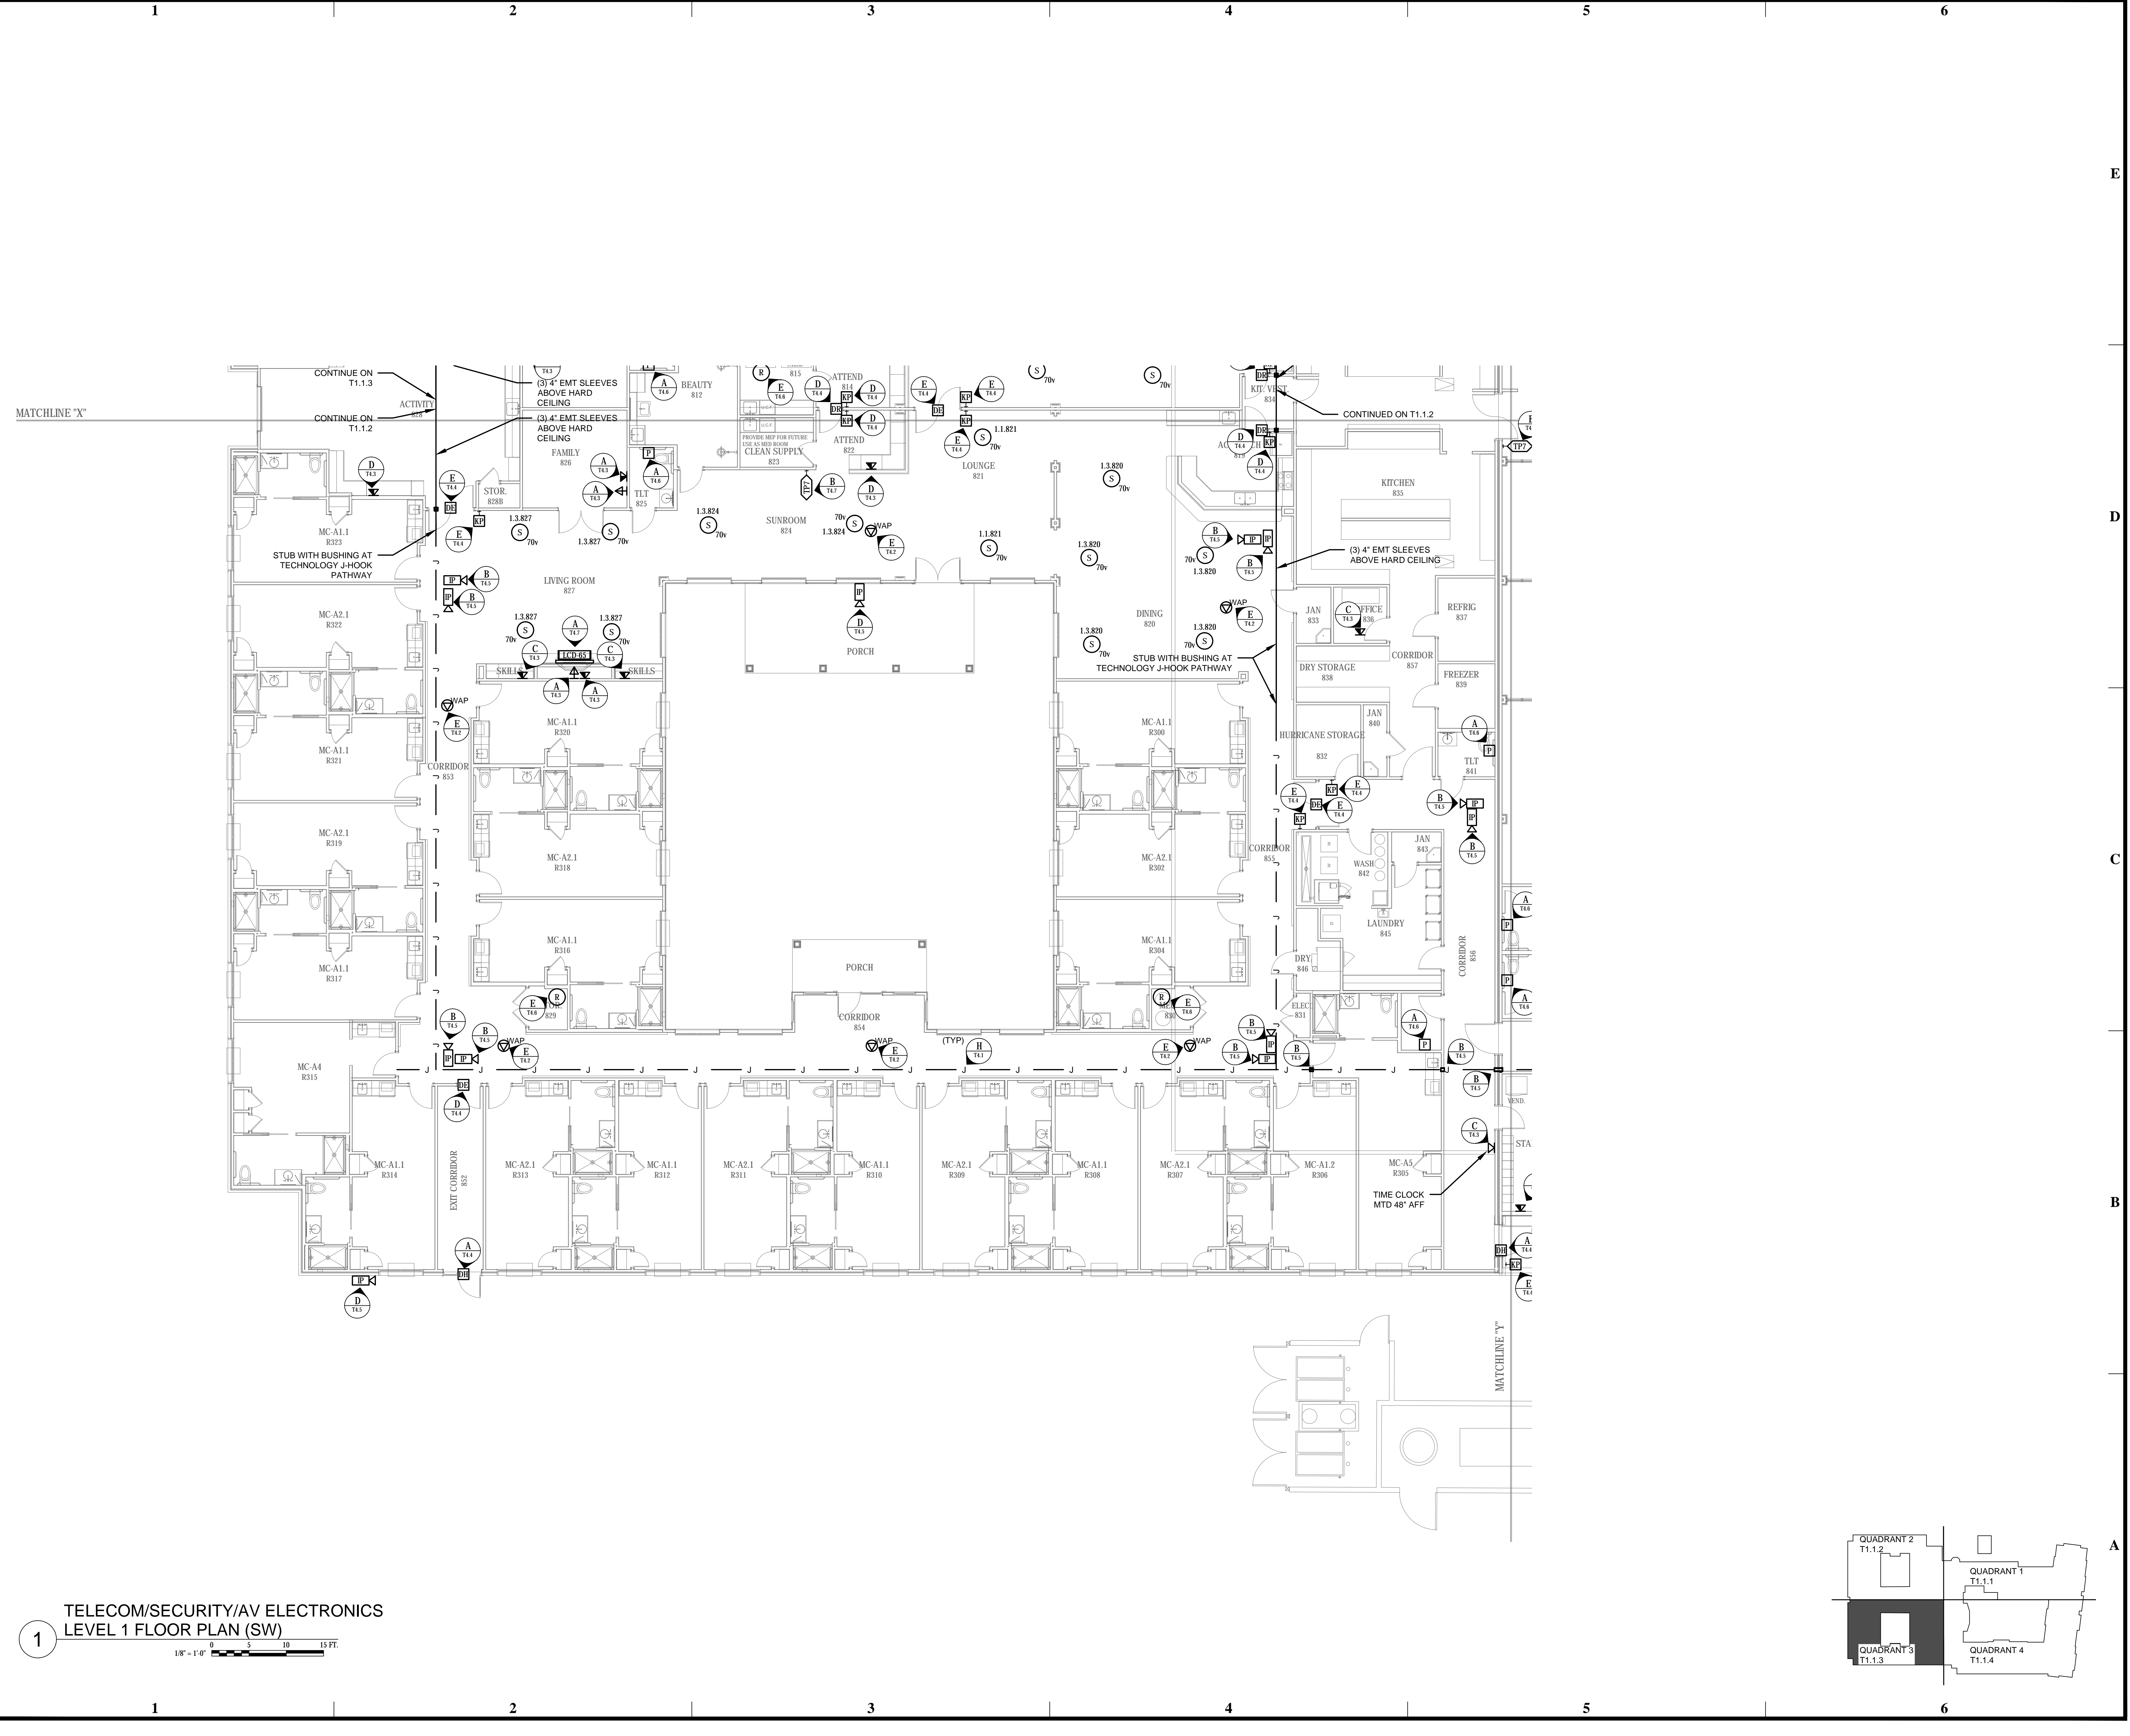

**TELECOM/SECURITY/AV ELECTRONICS
 LEVEL 1 FLOOR PLAN (SW)**

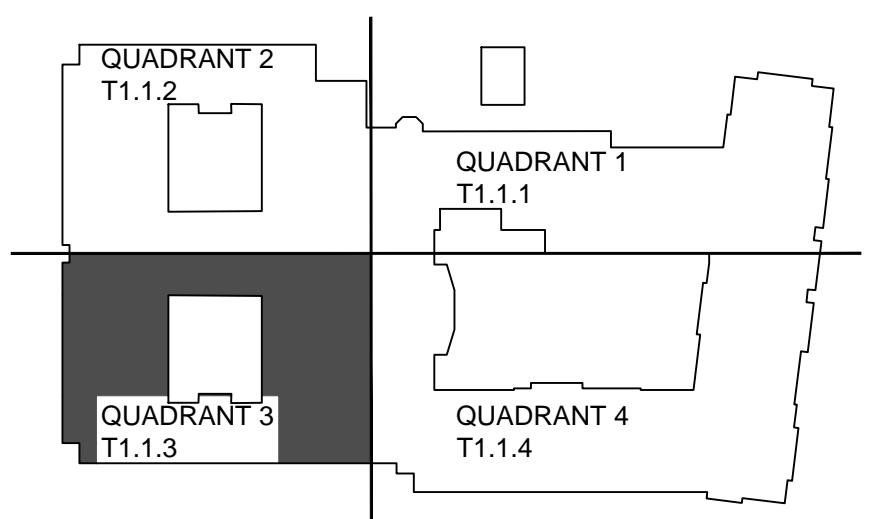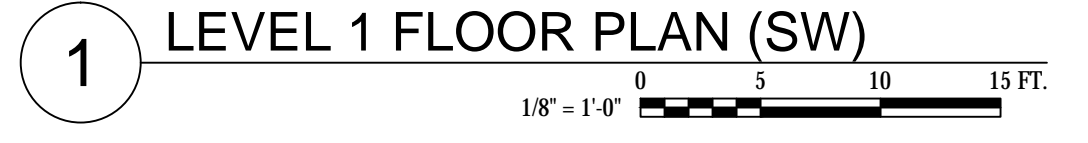

BIM Server: SERVER2016 - BIM Server 19/14017, Concordia Baton Rouge | Ver. 18.001 | Monday, February 22, 2016 | 3:34 PM