

**WATERSTONE AT BATON ROUGE  
 ASSISTED LIVING & MEMORY CARE**

SIEGEN LANE  
 BATON ROUGE, LA 70810


ISSUE: QA  
 CONSTRUCTION  
 DOCUMENTS

©2016 PI ARCHITECTS, INC.


REVISIONS:

DATE: 03/03/2016  
 PROJECT NUMBER: 14017  
 SHEET TITLE: TELECOM/SECURITY/AV ELECTRONICS  
 LEVEL 1 FLOOR PLAN  
 OVERALL

SHEET: T1.1

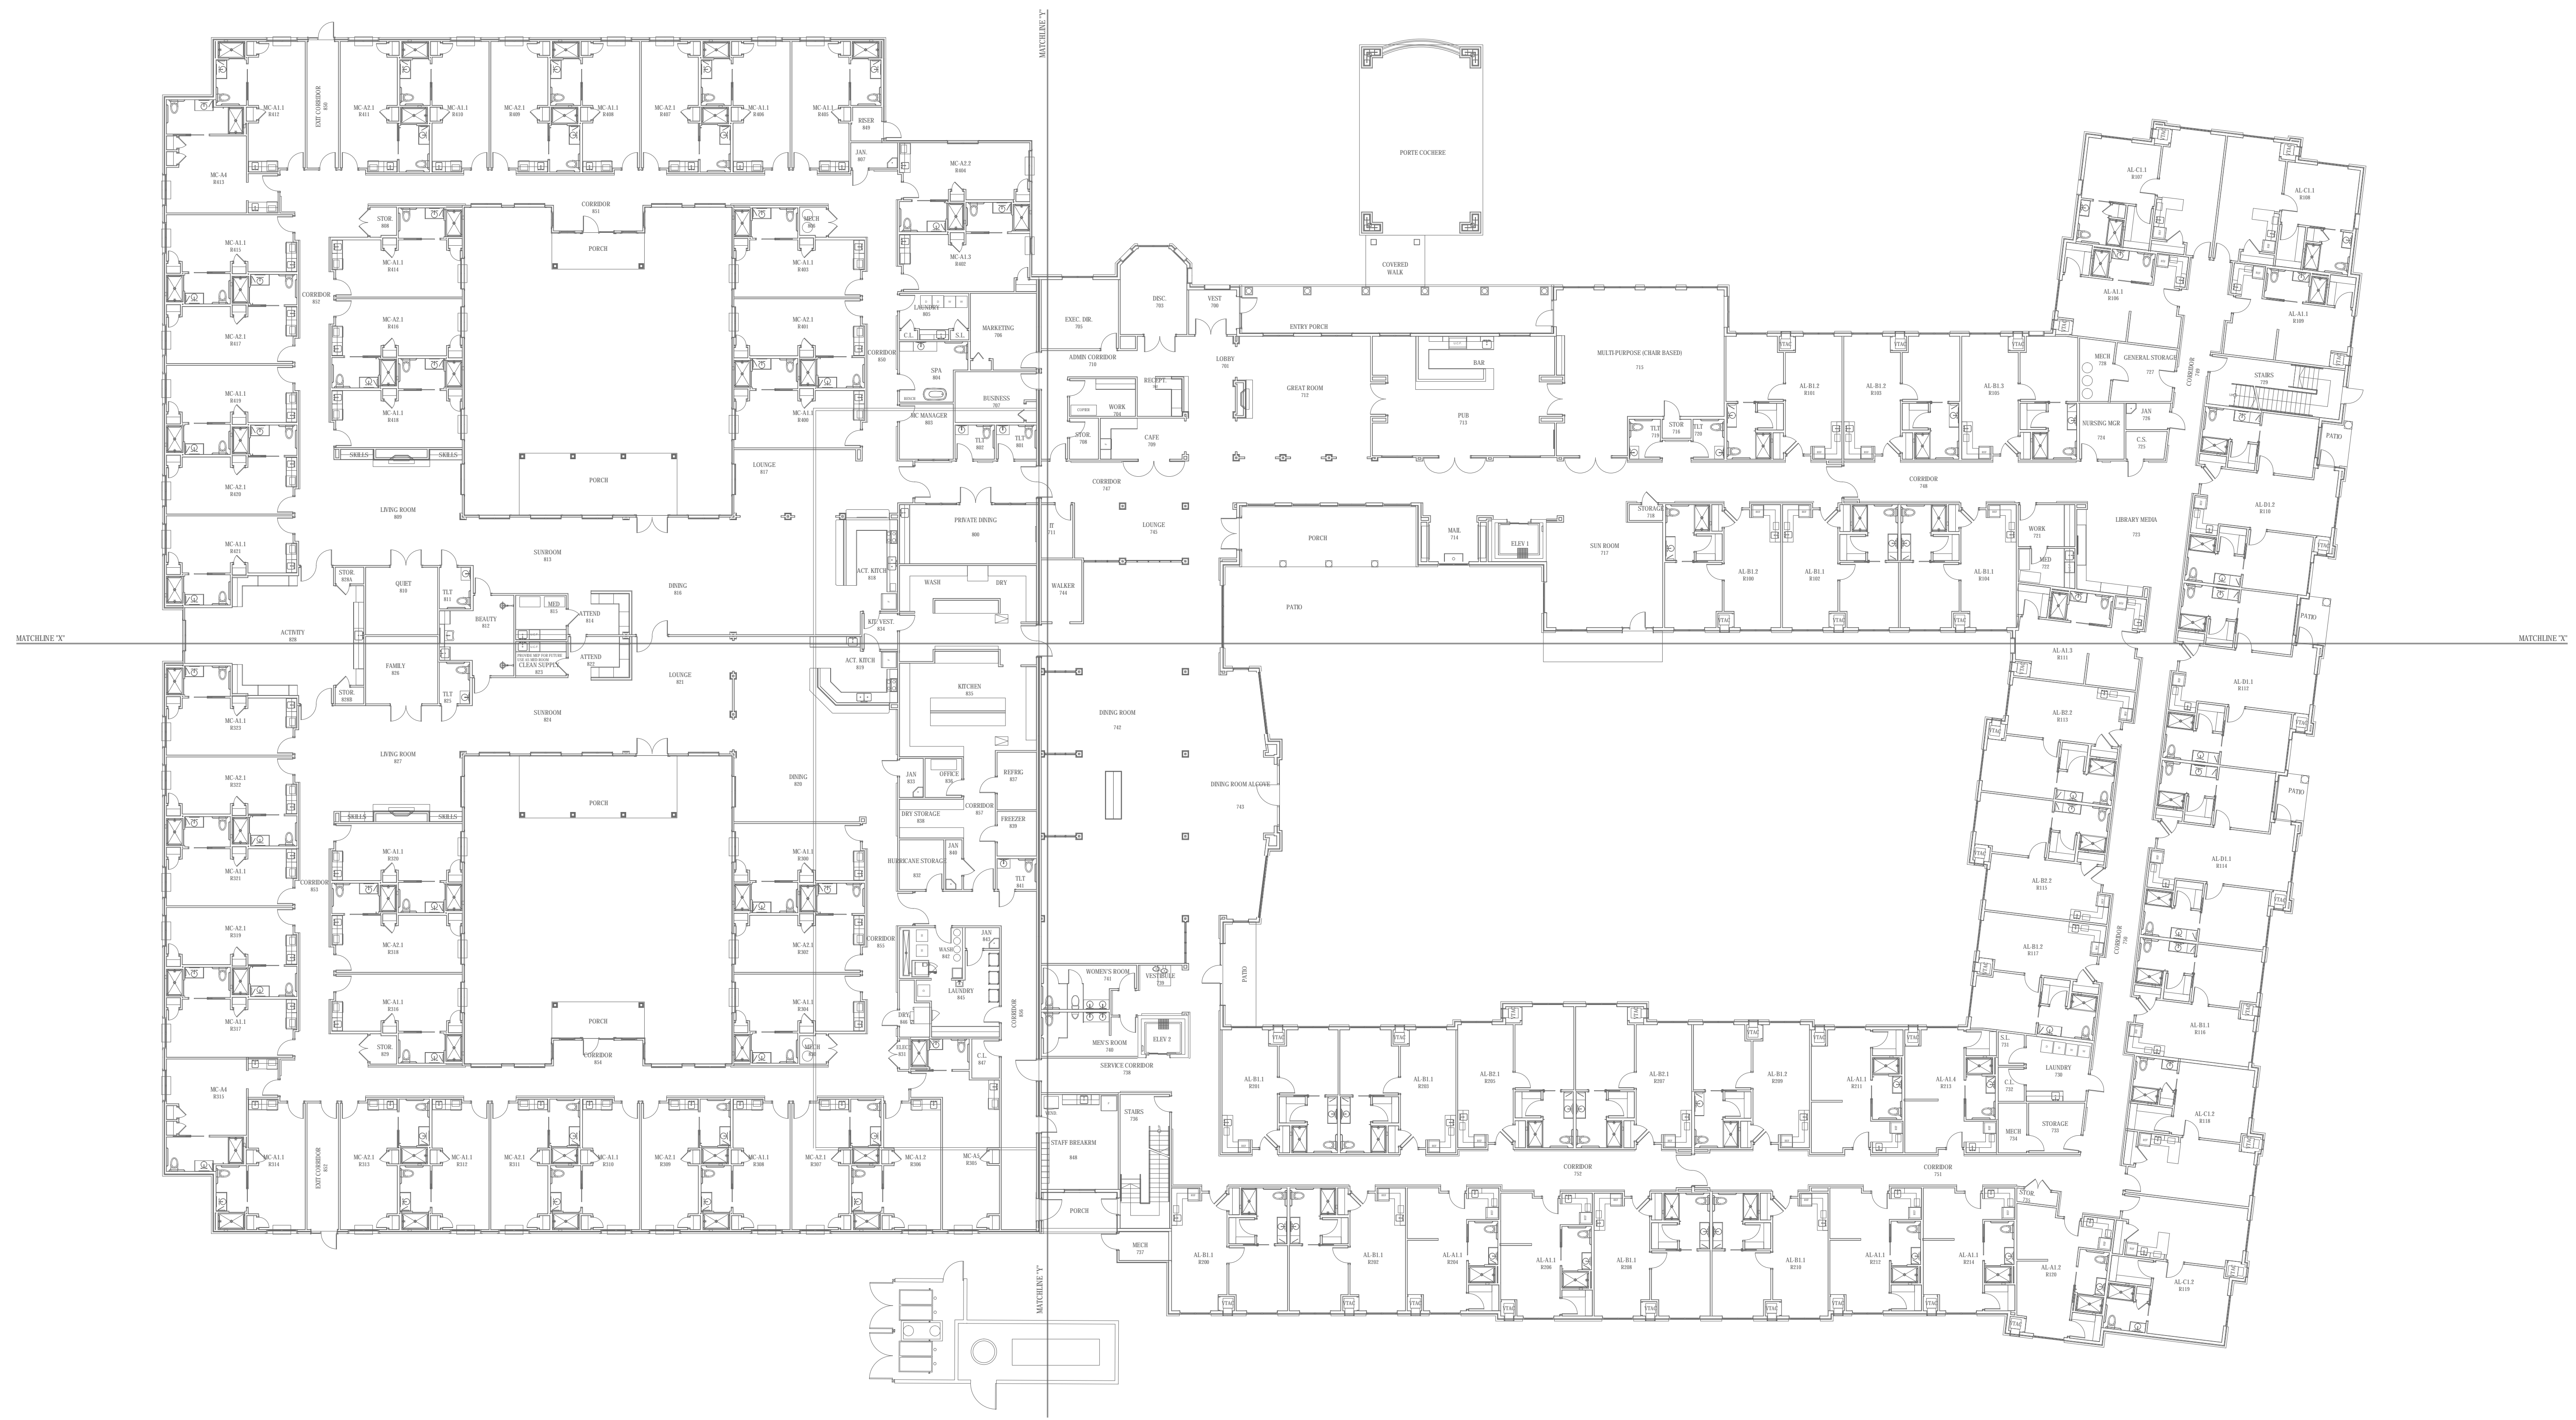

 **1 TELECOM/SECURITY/AV ELECTRONICS  
 LEVEL 1 FLOOR PLAN OVERALL**



BIM Server: SERVER2016 - BIM Server 19/14017 Concrads Baton Rouge | Ver. 18.001 | Monday, February 22, 2016 | 3:34 PM