

KEYNOTES:

- (2) 1-1/4" STUBBED TO LADDER RACK IN IT ROOM 311 BELOW.
- (2) 1-1/4" STUBBED TO WEATHERHEAD ON ROOF ABOVE.

**WATERSTONE AT BATON ROUGE
 ASSISTED LIVING & MEMORY CARE**


SIEGEN LANE
 BATON ROUGE, LA 70810

ISSUE: QA
 CONSTRUCTION DOCUMENTS

©2016 PI ARCHITECTS, INC.


REVISIONS:

DATE: 03/03/2016
 PROJECT NUMBER: 14017
 SHEET TITLE: TELECOM/SECURITY/AV ELECTRONICS LEVEL 2 FLOOR PLAN (NE)
 SHEET: T1.2.1

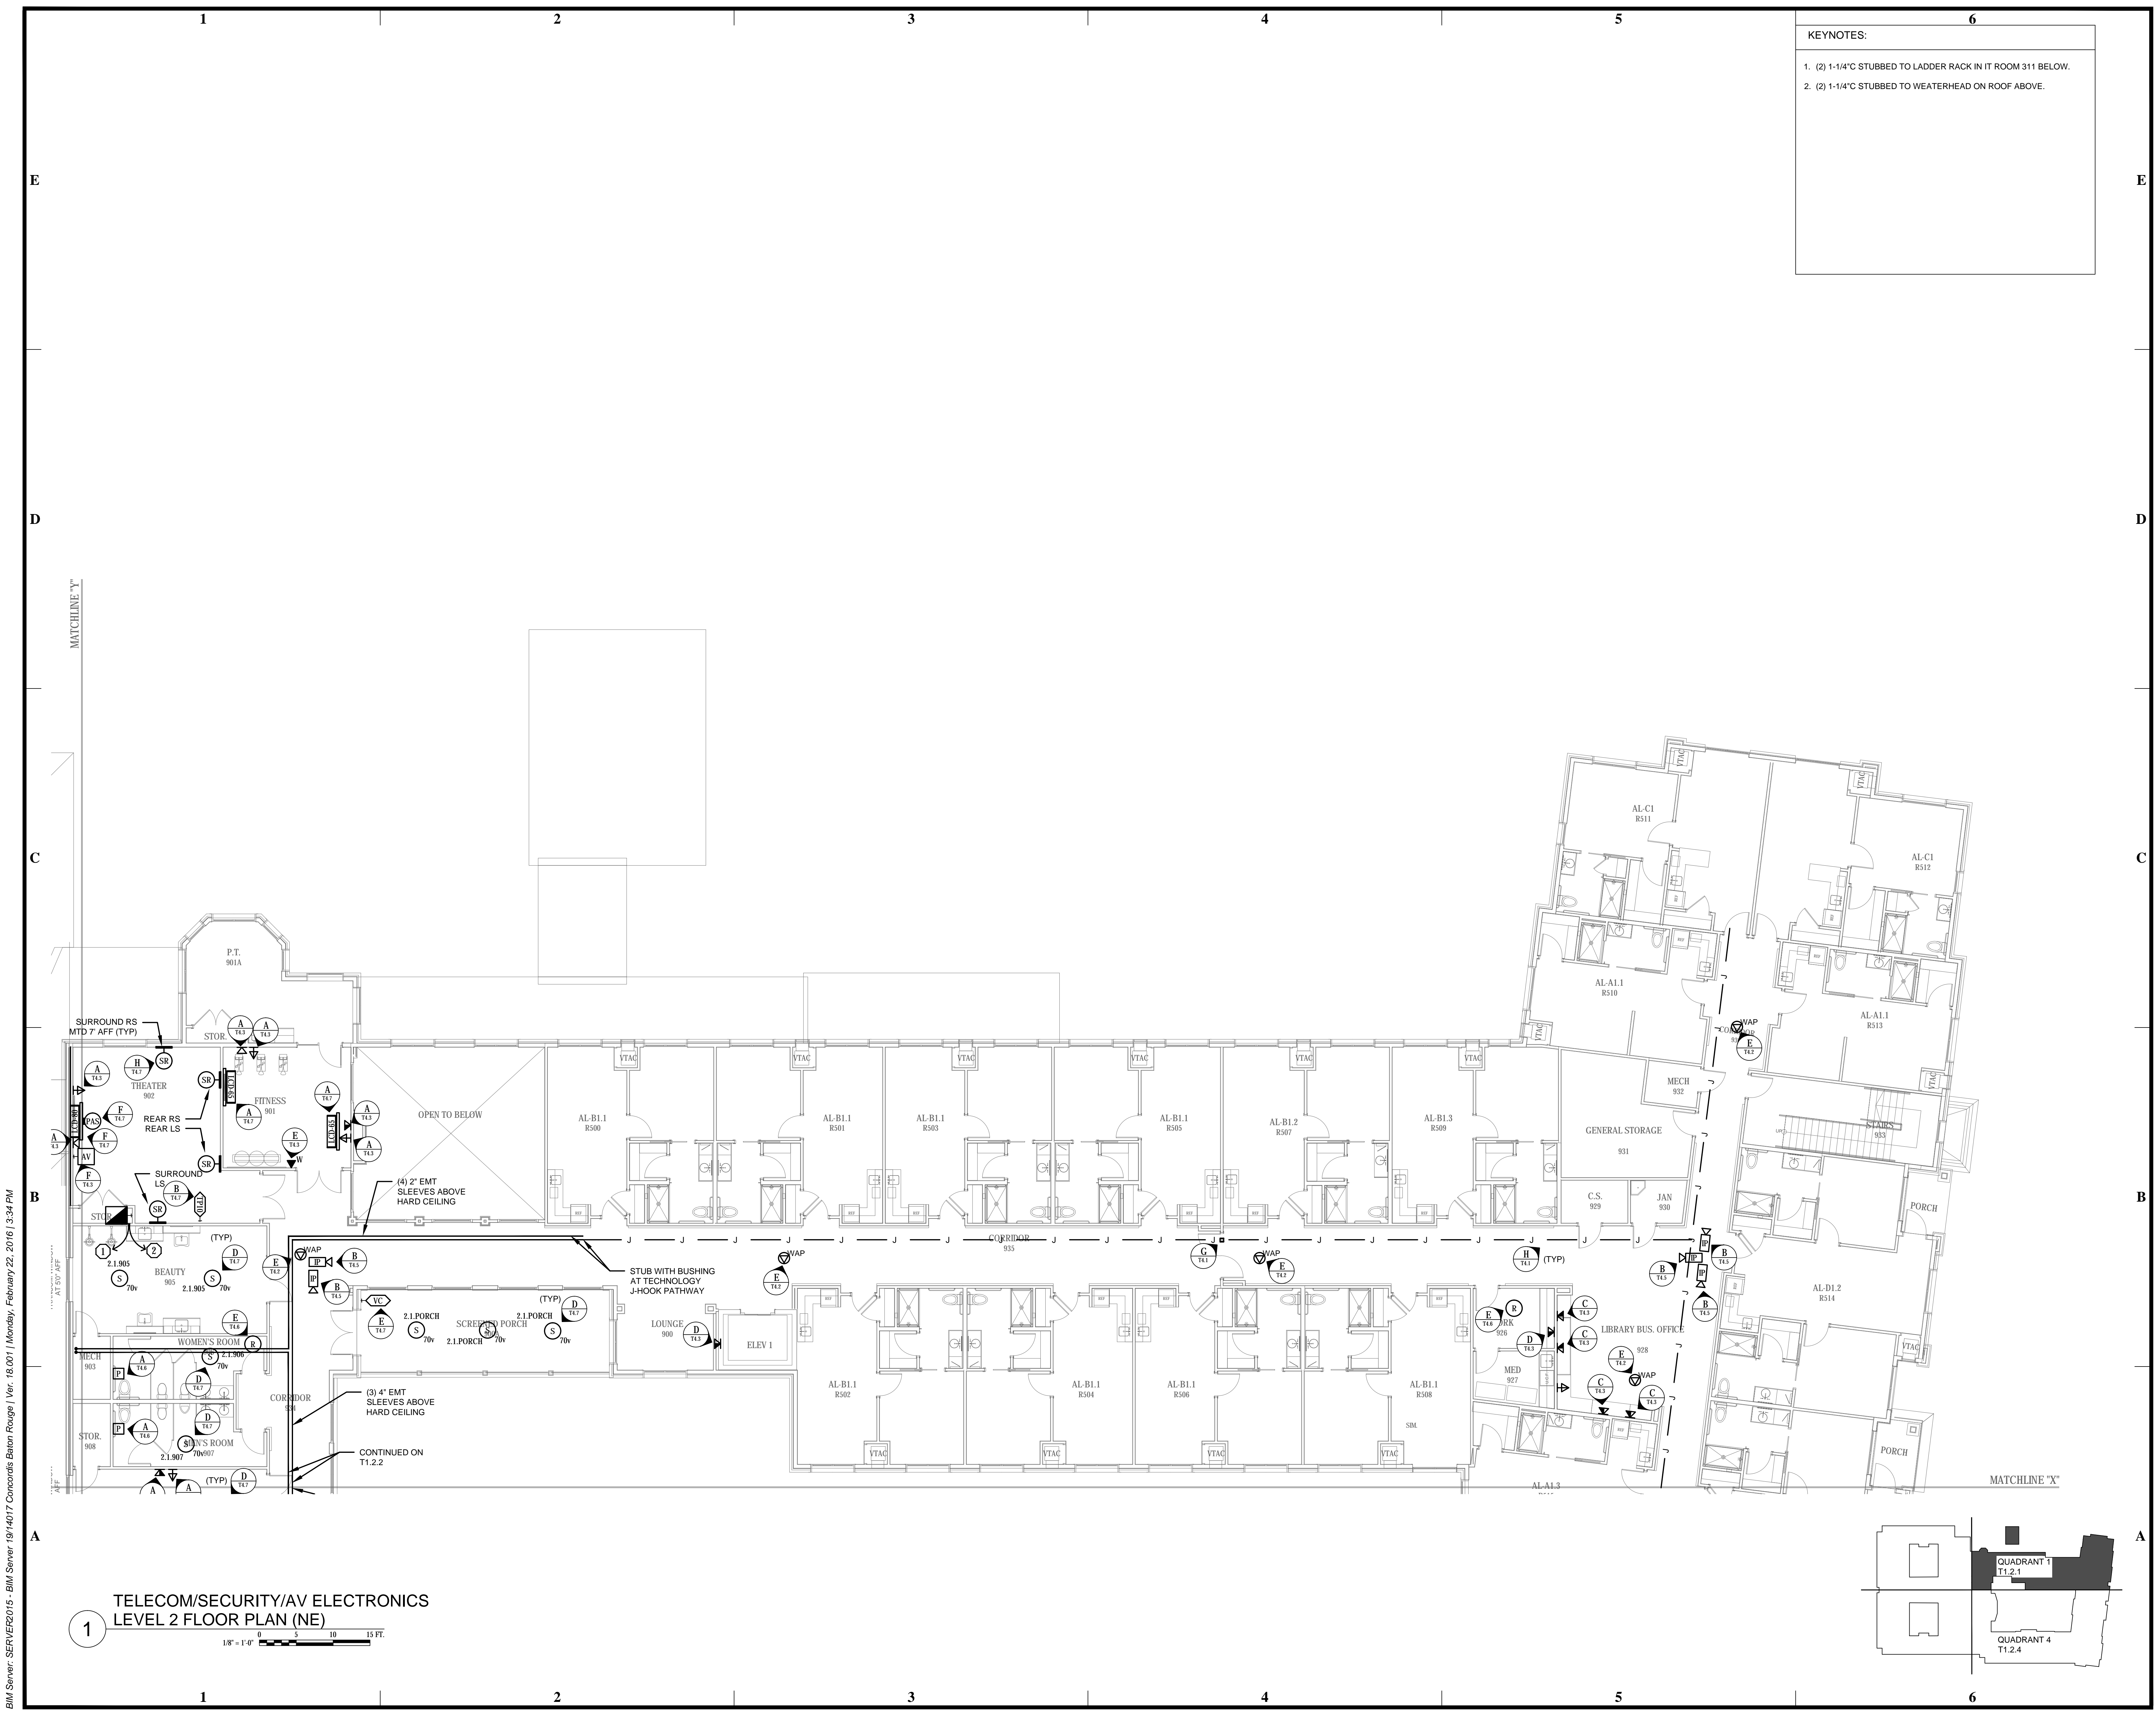

**1 TELECOM/SECURITY/AV ELECTRONICS
 LEVEL 2 FLOOR PLAN (NE)**

1/8" = 1'-0"

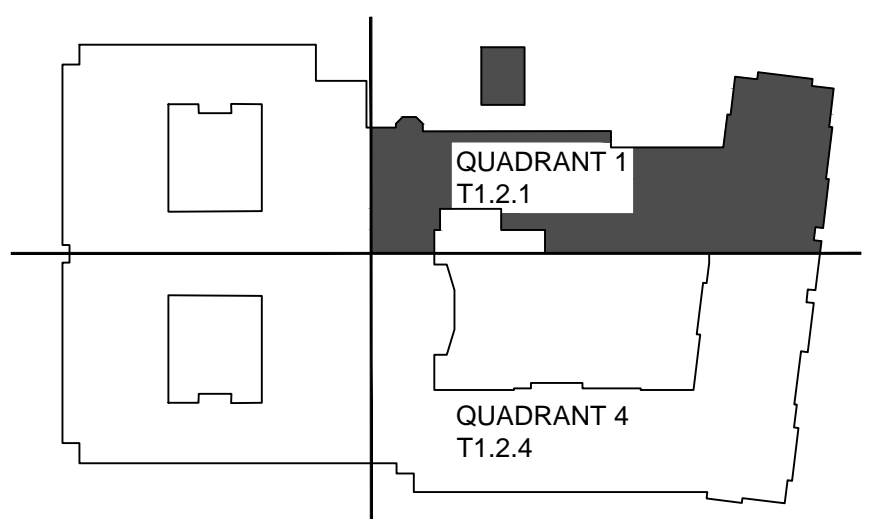

BIM Server: SERVER2015 - BIM Server 19/14017, Concordia Baton Rouge | Ver. 18.001 | Monday, February 22, 2016 | 3:34 PM