



WATERSTONE AT BATON ROUGE

ASSISTED LIVING & MEMORY CARE

 SIEGEN LANE

 BATON ROUGE, LA 70810

ISSUE: PERMIT SET

©2016 PI ARCHITECTS, INC.


REVISIONS:

DATE: 03/31/2016


 PROJECT NUMBER: 14017

 SHEET TITLE: MC UNIT REFLECTED CEILING PLANS


SHEET: A9.4

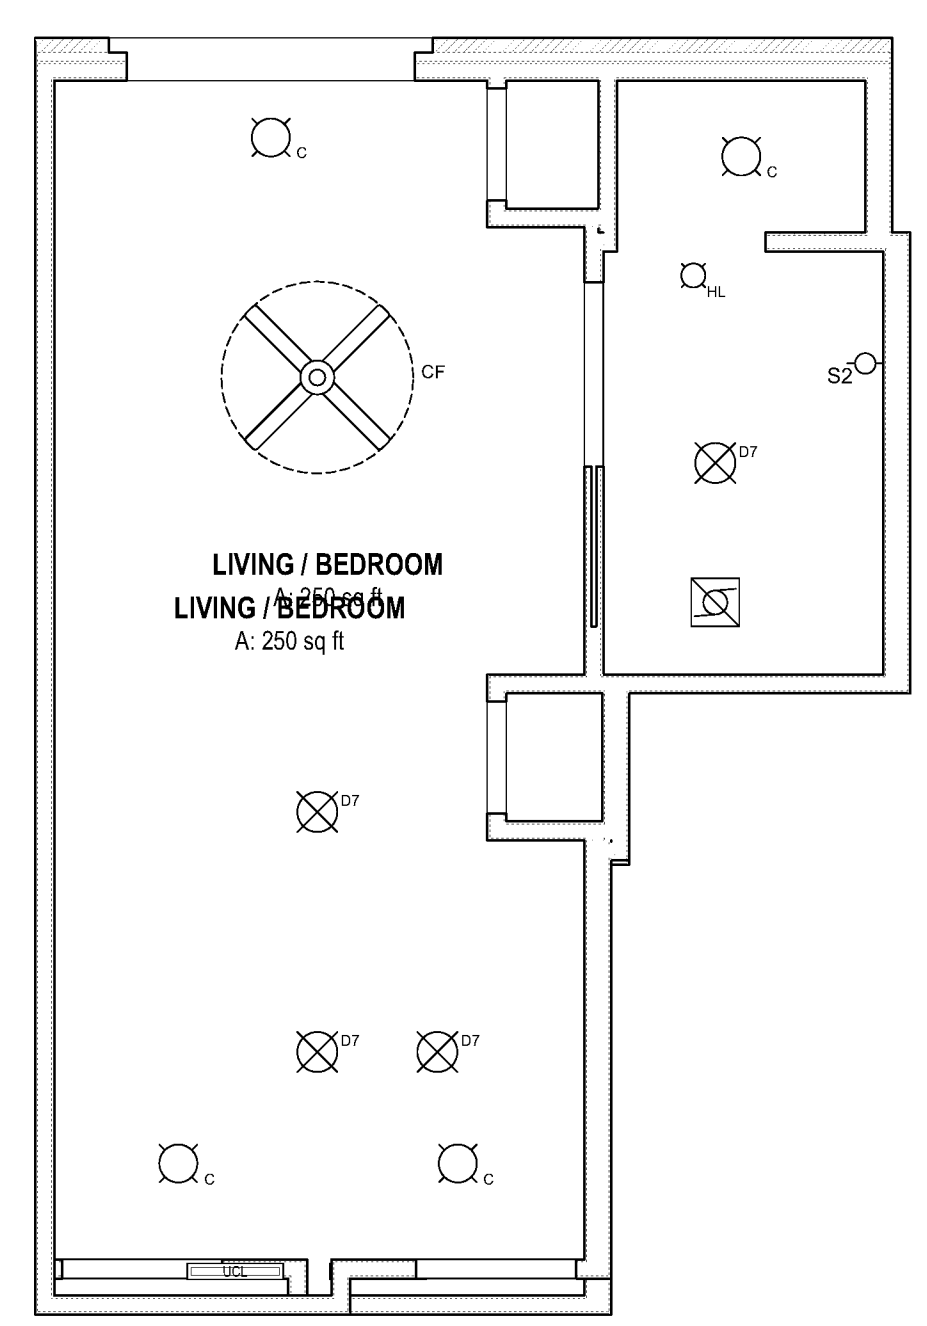


D1 UNIT RCP : MC-A2 STUDIO
SCALE: 1/4" = 1'-0"

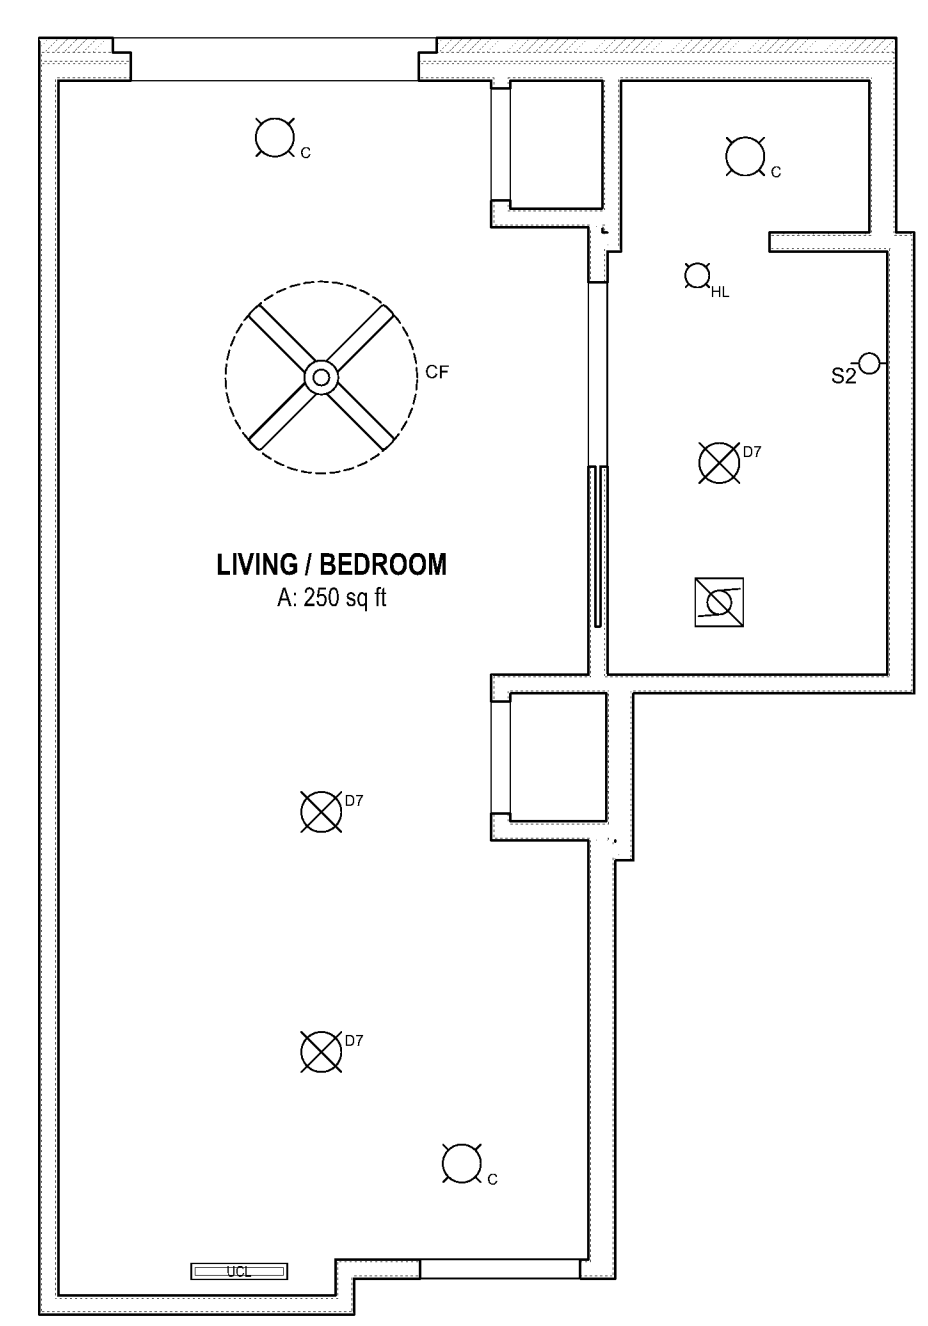


D2 UNIT RCP : MC-A2 STUDIO
SCALE: 1/4" = 1'-0"

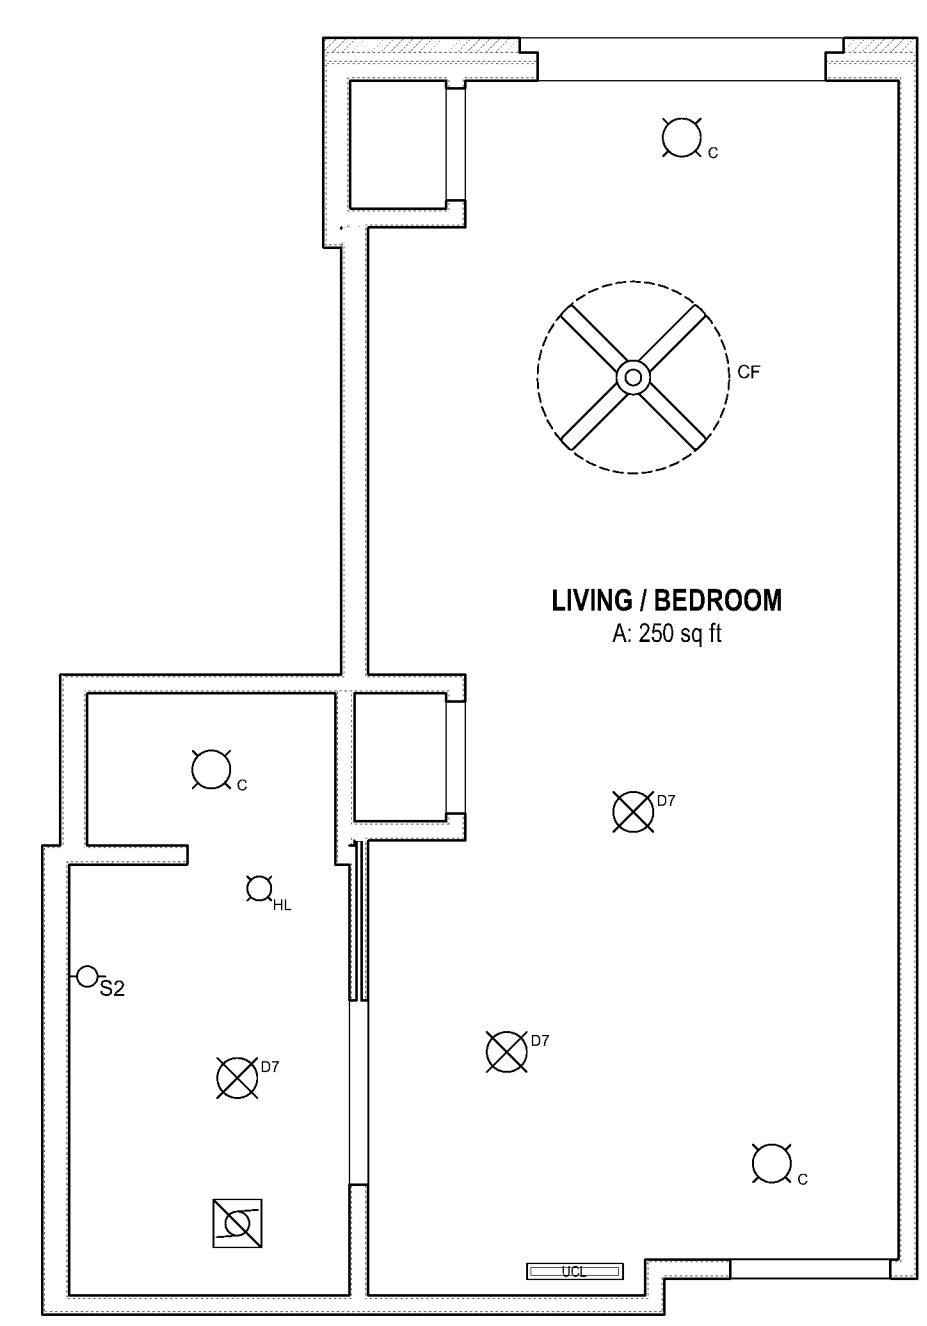

D3 UNIT RCP : MC-A3 STUDIO
SCALE: 1/4" = 1'-0"

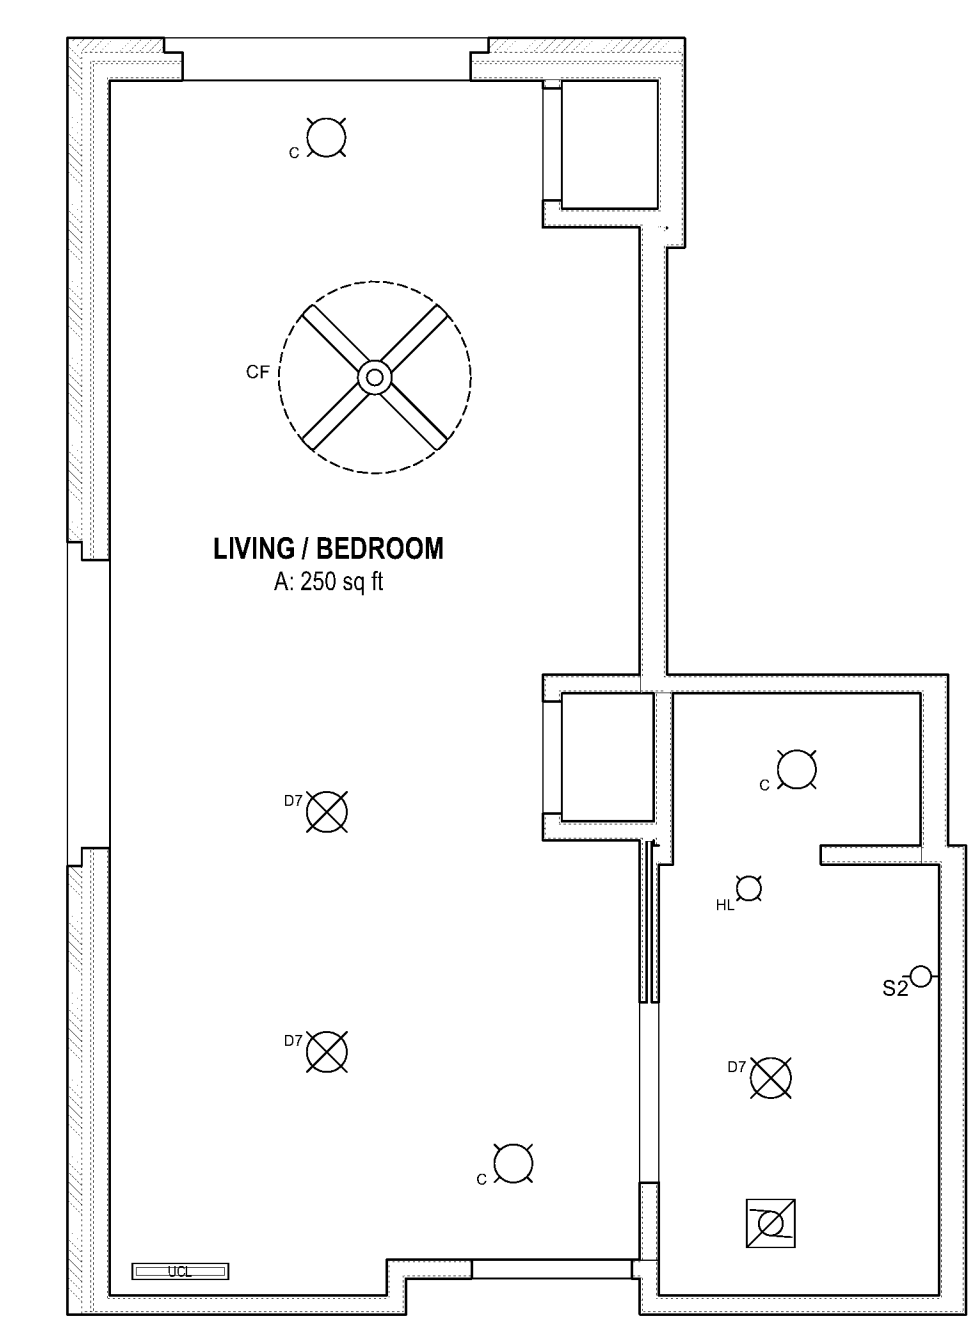

D5 UNIT RCP : MC-A4 STUDIO
SCALE: 1/4" = 1'-0"

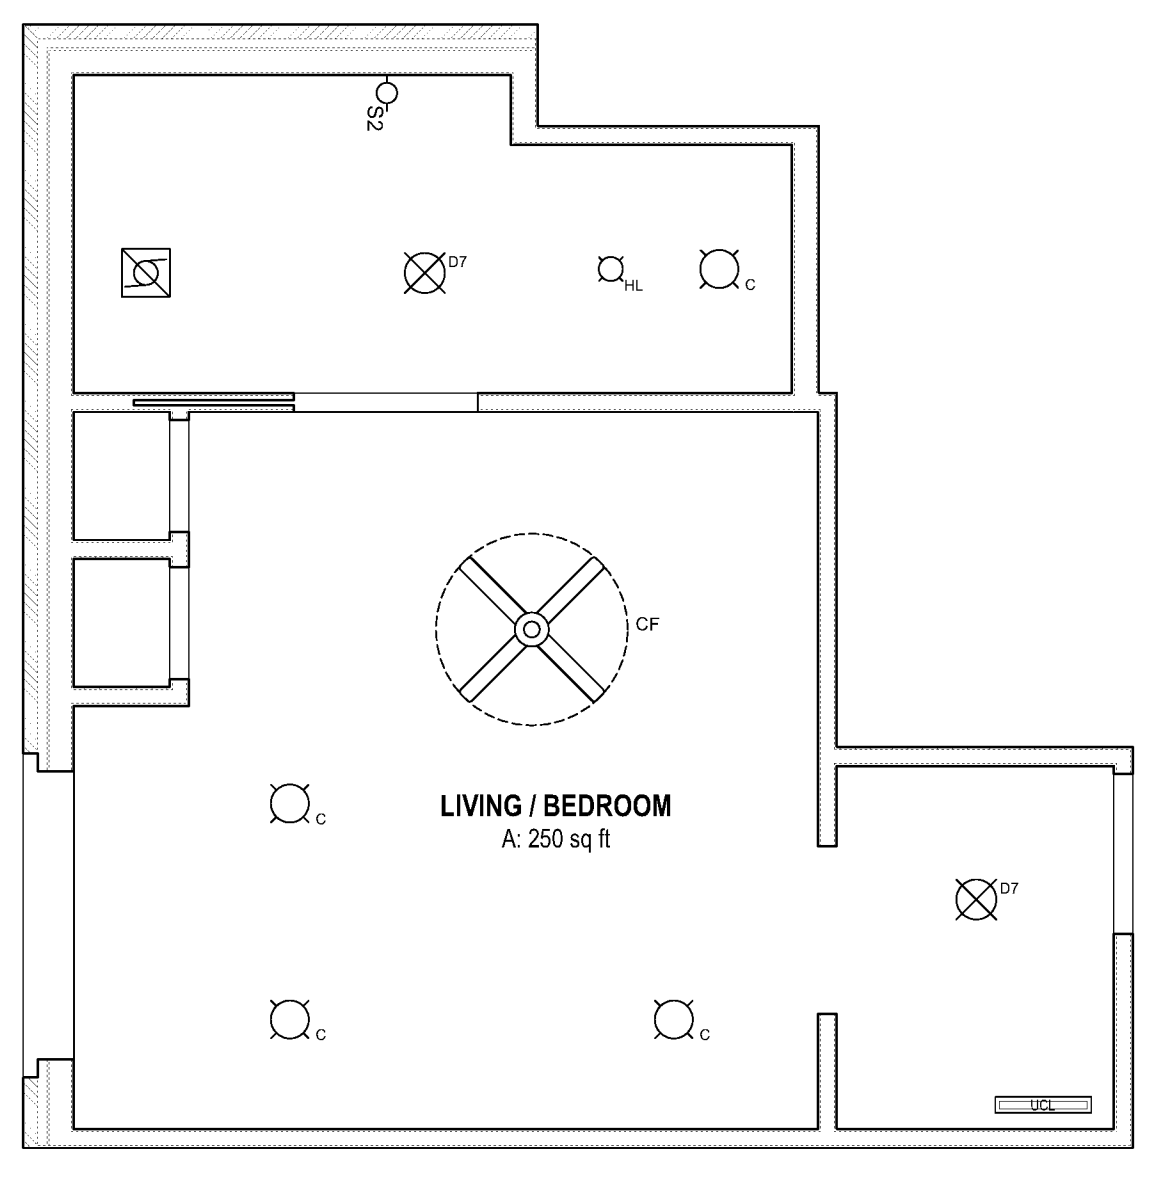

B1 UNIT RCP : MC-A4 STUDIO
SCALE: 1/4" = 1'-0"


 



 



 
 

 


 

 
RCP GENERAL NOTES

- ALL CEILINGS TO BE 9'-0" A.F.F. U.O..
- ALL RECESSED LIGHTING IN RATED CEILING ASSEMBLY TO HAVE GYPSUM BOARD ENCLOSURE PER UL RATED CEILING ASSEMBLY; REF: DETAIL D9/A9.5
- ENSURE THE INSTALLATION OF SHATTERPROOF LENSES ON THE DOWN LIGHTS LOCATED IN ALL SHOWERS.
- CENTER VANITY FIXTURE ON SINK. RE: INTERIOR ELEVATIONS

RCP KEYED NOTES

- 20" X 30" 60 MIN. RATED ATTIC ACCESS HATCH.
- 48" X 22" 60 MIN. RATED ATTIC ACCESS HATCH.
- DECORATIVE BEAM, TYP.; REF: B4/A8.5
- FRAMING/STRUCTURAL SUPPORT FOR KITCHEN VENTING HOOD; REF: STRUCT AND MECH.
- KITCHEN VENT HOOD
- 1 HR RATED ROOF ACCESS HATCH.
- (PWC-1) PAINTED WOOD CROWN MOLDING; RE: INTERIOR FINISH SCHEDULE & LEGEND

RCP SYMBOLS LEGEND

	DECORATIVE WALL SCONCE; RE: ELECTRICAL FOR LUMINAIRE SCHEDULE		EXHAUST FAN
	RECESSED CAN LIGHT; RE: ELECTRICAL FOR LUMINAIRE SCHEDULE		DIFFUSER
	RECESSED WALL WASHER; RE: ELECTRICAL FOR LUMINAIRE SCHEDULE		20" X 30" 1 HR. RATED ATTIC ACCESS PANEL
	LED SURFACE LIGHT; RE: ELECTRICAL FOR LUMINAIRE SCHEDULE		22" X 48" 1 HR. RATED RETRACTABLE ATTIC ACCESS PANEL
	RECESSED HEAT LAMP ON TIMER; RE: ELECTRICAL FOR LUMINAIRE SCHEDULE		EXPANSION JOINT; RE: DETAIL D4/A9.5
	DECORATIVE LIGHT FIXTURE; RE: ELECTRICAL FOR LUMINAIRE SCHEDULE		WOOD BEAM; RE: DETAIL
	UNDER CABINET LIGHT; RE: ELECTRICAL FOR LUMINAIRE SCHEDULE		GYPSUM FURREDOWN; RE: REFLECTED CEILING PLAN FOR CEILING HEIGHTS
	1 X 4 FLUORESCENT SURFACE-MOUNT LIGHT FIXTURE; RE: ELECTRICAL FOR LUMINAIRE SCHEDULE		1 HR. RATED CEILING ASSEMBLY; 2 LAYERS 5/8" TYPE "X" GYPSUM BOARD
	CEILING FAN; RE: ELECTRICAL FOR LUMINAIRE SCHEDULE		24" X 24" ACOUSTICAL CEILING TILE; RE: SPECIFICATIONS

BIM Server: SERVER2015 - BIM Server 19/14017 Concordia Baton Rouge | Ver. 19.0011 Friday, April 01, 2016 | 12:53 AM