

BIM Server: Server\2012 - BIM Server\18.0\14017 Concordia Baton Rouge\18.001 Wednesday, September 02, 2015 14:04 PM

E  
D  
C  
B  
A


1 2 3 4 5 6

**PLAN NOTES:**

- 1. CONNECT ALL LIGHTING IN THIS STAIR TO ONE CIRCUIT AS INDICATED ON FIRST FLOOR PLAN.
- 2. PROVIDE LIGHTING CONTROL PANEL BY GREENGATE OR EQUIVALENT TO CONTROL ALL LIGHTING AND TENANT SIGNAGE. SEE DETAIL #29 THIS SHEET E1.1.1 OR MORE INFORMATION.


**GENERAL NOTES:**

- A. ALL LIGHTING SHALL MEET OR EXCEED ALL NEC STANDARDS.
- B. SEE MAIN ELECTRICAL GENERAL NOTES FOR MORE INFORMATION.
- C. COORDINATE ALL LIGHTING WITH OTHER TRADES PRIOR TO ROUGH-IN.
- D. VERIFY EJECTOR LOCATIONS AND MOUNTING HEIGHTS OR ALL LIGHTING SHALL BE MOUNTED TO THE CEILING.
- E. ALL EMERGENCY LIGHTING SHALL BE PROVIDED WITH AN UNDERLAMP.
- F. ALL LIGHTING SHALL BE INSTALLED TO THE FINISH SURFACE UNLESS OTHERWISE NOTED.
- G. ALL LIGHTING SHALL BE INSTALLED TO THE FINISH SURFACE UNLESS OTHERWISE NOTED.
- H. VERIFY THE COLOR OF ALL LIGHTING FIXTURES, DEVICES, AND COVER PLATES WITH THE OWNER.
- I. ALL LIGHTING IN CLOSETS SHALL CONFORM TO NEC ARTICLE 410.8.
- J. ALL OCCUPANCY SENSORS SHALL BE INSTALLED TO THE FINISH SURFACE UNLESS OTHERWISE NOTED.

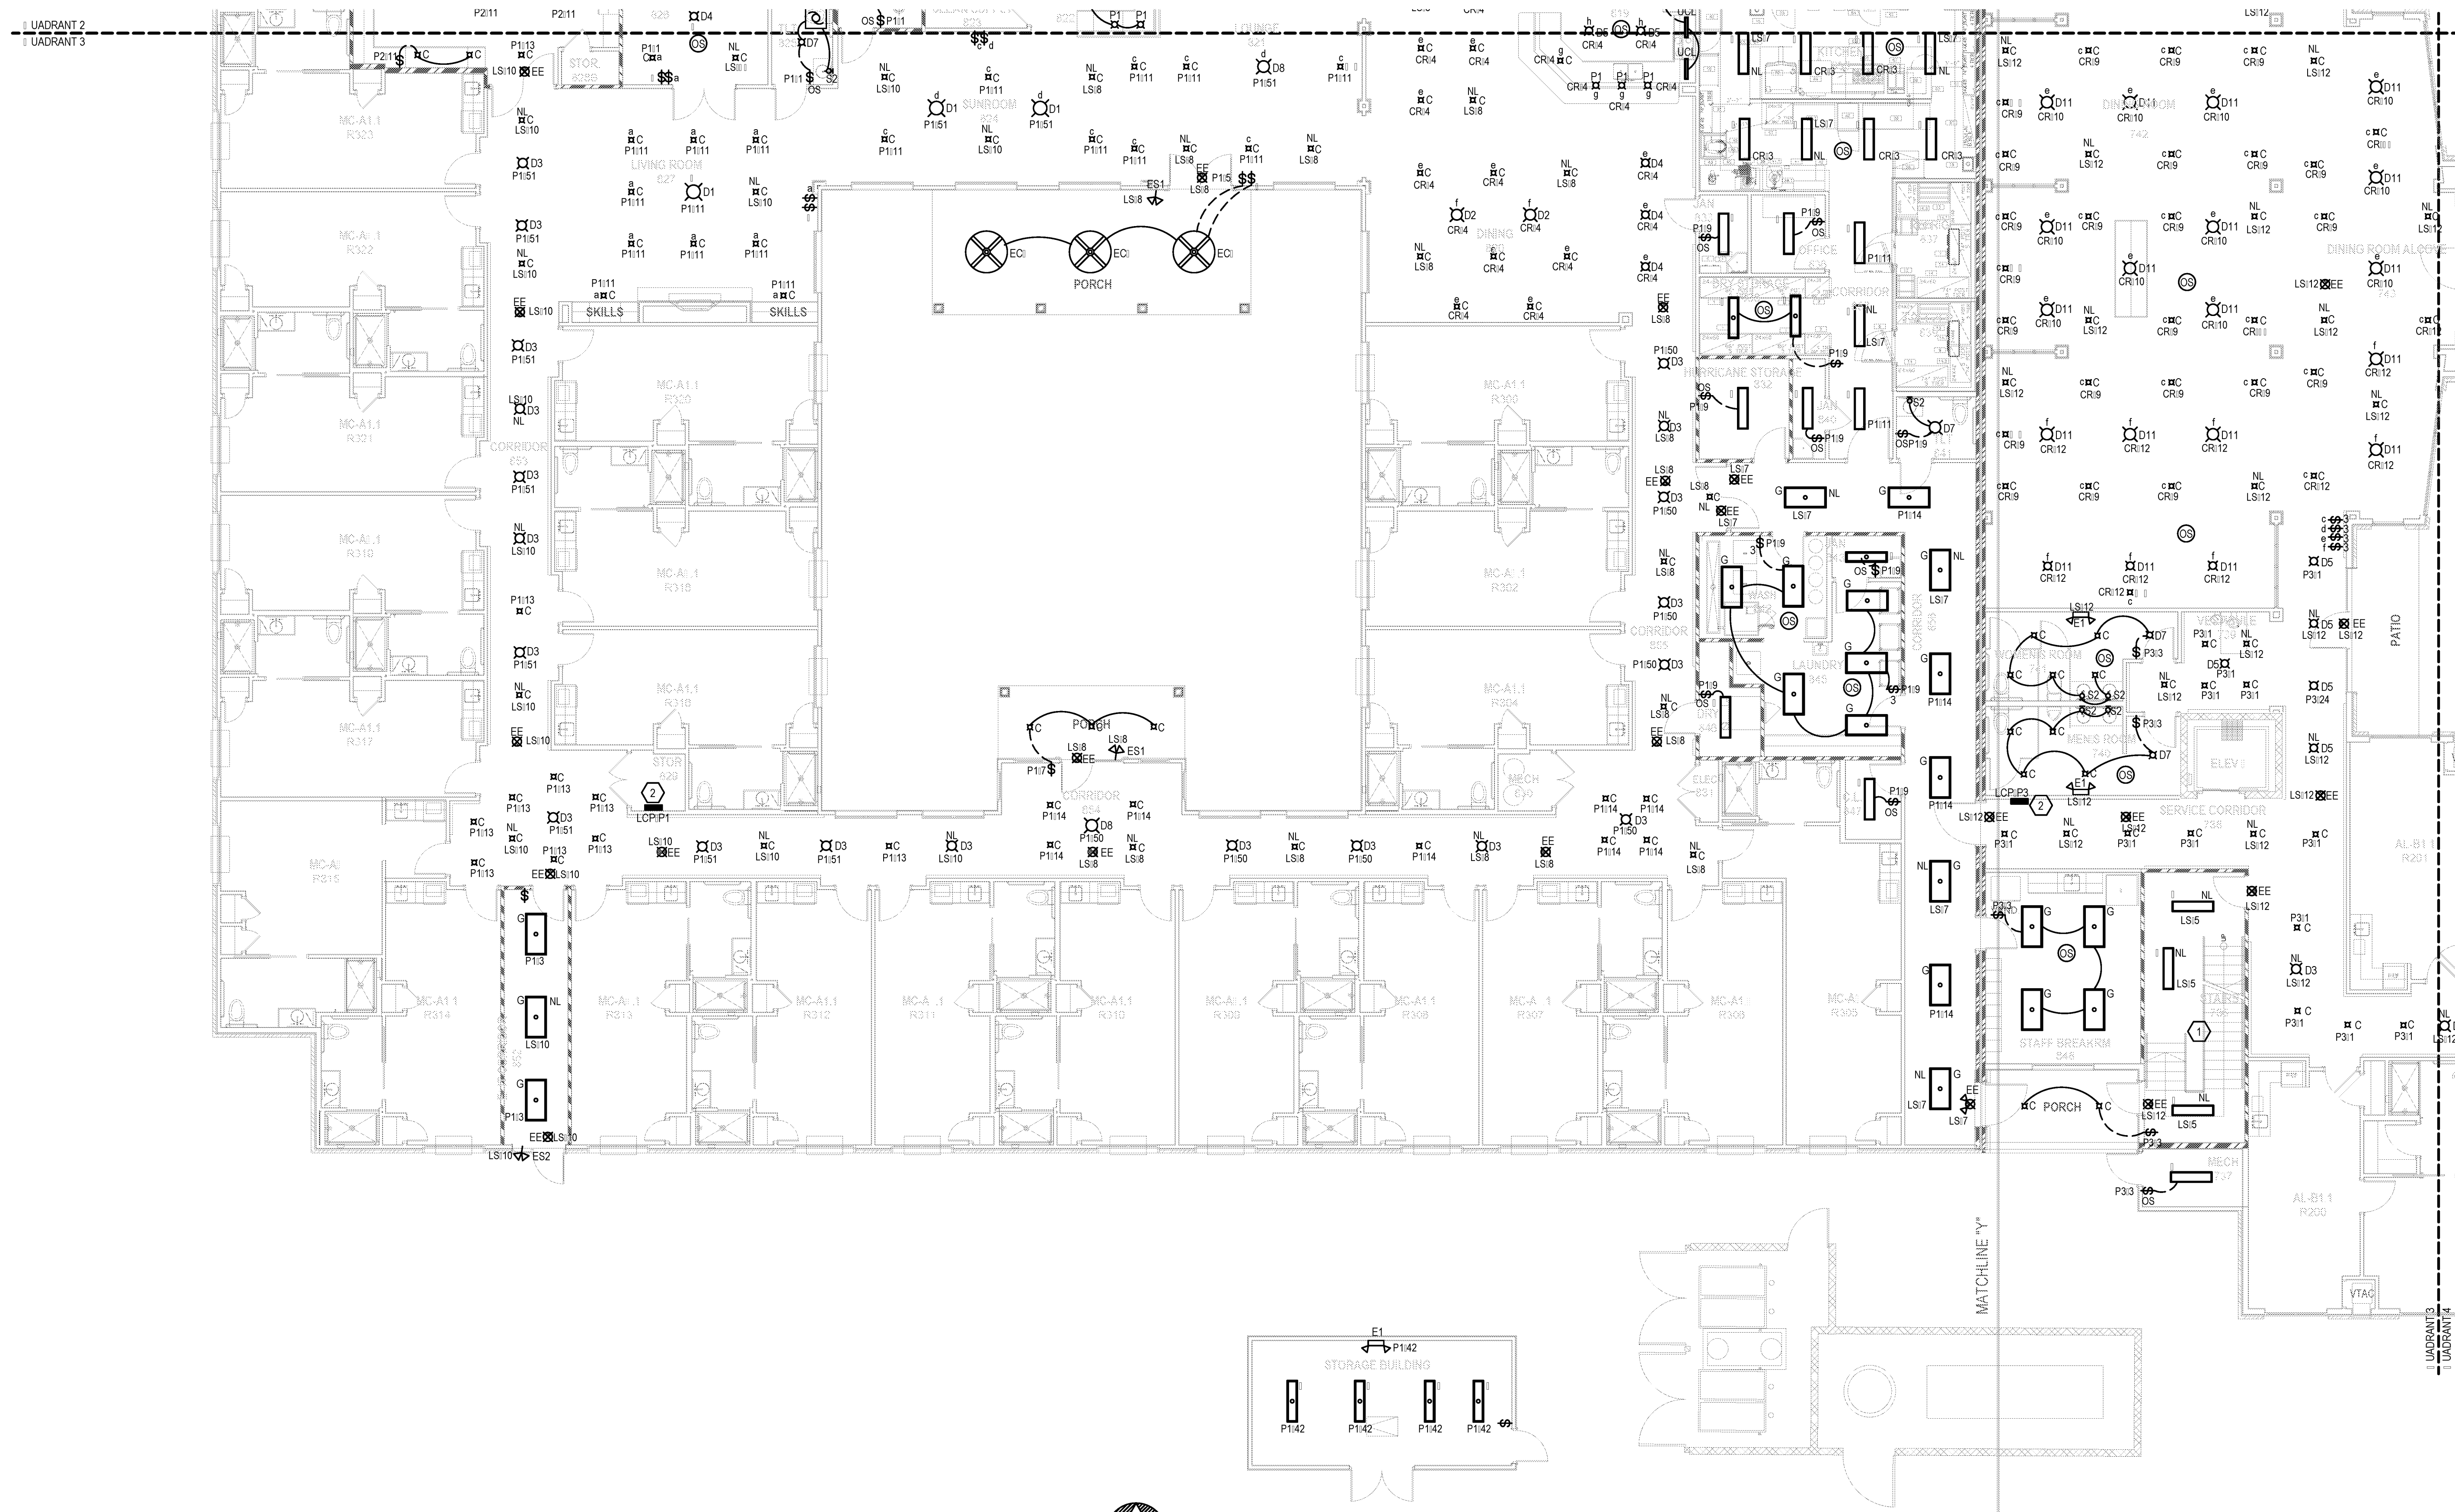

**1 | LIGHTING PLAN | 1ST FLOOR**  
E1.1.3 | 18" x 110"

**2 | LIGHTING PLAN | STORAGE BUILDING**  
E1.1.3 | 18" x 110"

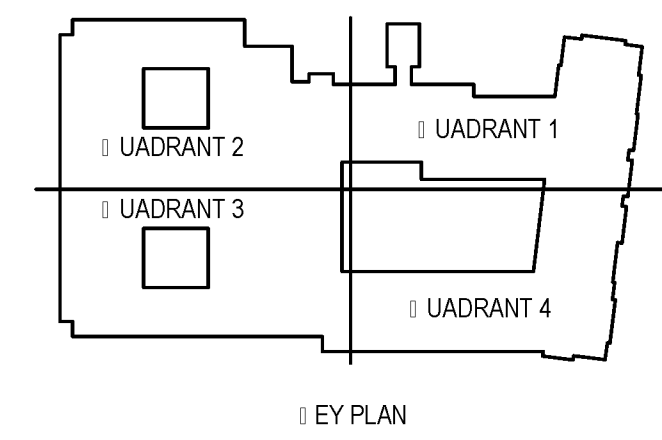

**CONTRACTOR NOTE:**  
IT IS THE RESPONSIBILITY OF THE CONTRACTOR TO NOTIFY THE ARCHITECT, LANDLORD AND TENANT OF ANY DISCREPANCIES ENCOUNTERED ON THE PLANS OR IN EXISTING SITE CONDITIONS PRIOR TO SUBMISSION OF BID.  
BIDDERS ARE TO VISIT THE SITE AND FAMILIARIZE THEMSELVES AS TO THE NATURE AND SCOPE OF THE WORK. THE BASE BID SHALL INCLUDE MODIFICATIONS TO SYSTEMS AND DEVICES AS REQUIRED BY STATE, LOCAL AND FEDERAL CODES. WHETHER INDICATED OR NOT ON CONTRACT DOCUMENTS. THE SUBMISSION OF A BID SHALL BE EVIDENCE THAT SUCH AN EXAMINATION AND COMPLIANCE WITH GOVERNING CODES/REGULATIONS HAS BEEN MADE. LATER CLAIMS OR LABOR EQUIPMENT OR MATERIALS REQUIRED OR OBTAINED BY THE CONTRACTOR WHICH COULD HAVE BEEN FORESEEN HAD AN EXAMINATION AND CODES/REGULATIONS REVIEW BEEN MADE, WILL NOT BE ALLOWED.

**pi architects**  
3500 Jefferson St. Suite 303  
Austin, TX 78731  
P: (512) 231-1910  
F: (512) 231-1950  
www.piarch.com  
architecture + interior design + landscape architecture  
**PE SERVICES**  
Professional Engineer  
Louisiana License No. 30319

**WATERSTONE AT BATON ROUGE  
ASSISTED LIVING & MEMORY CARE**  
SIEGEN LANE  
BATON ROUGE, LA 70810

ISSUE: PERMIT SET

REVISIONS:

DATE: 03/31/2016  
PROJECT NUMBER: PES 15090  
SHEET TITLE: LIGHTING PLAN | 1ST FLOOR  
SHEET: E1.1.3