

**WATERSTONE AT BATON ROUGE
 ASSISTED LIVING & MEMORY CARE**

SIEGEN LANE
 BATON ROUGE, LA 70810


ISSUE: QA
 CONSTRUCTION
 DOCUMENTS

©2016 PI ARCHITECTS, INC.


REVISIONS:

DATE: 03/03/2016
 PROJECT NUMBER: 14017
 SHEET TITLE: TELECOM/SECURITY/AV ELECTRONICS LEVEL 1 FLOOR PLAN OVERALL

SHEET: T1.1

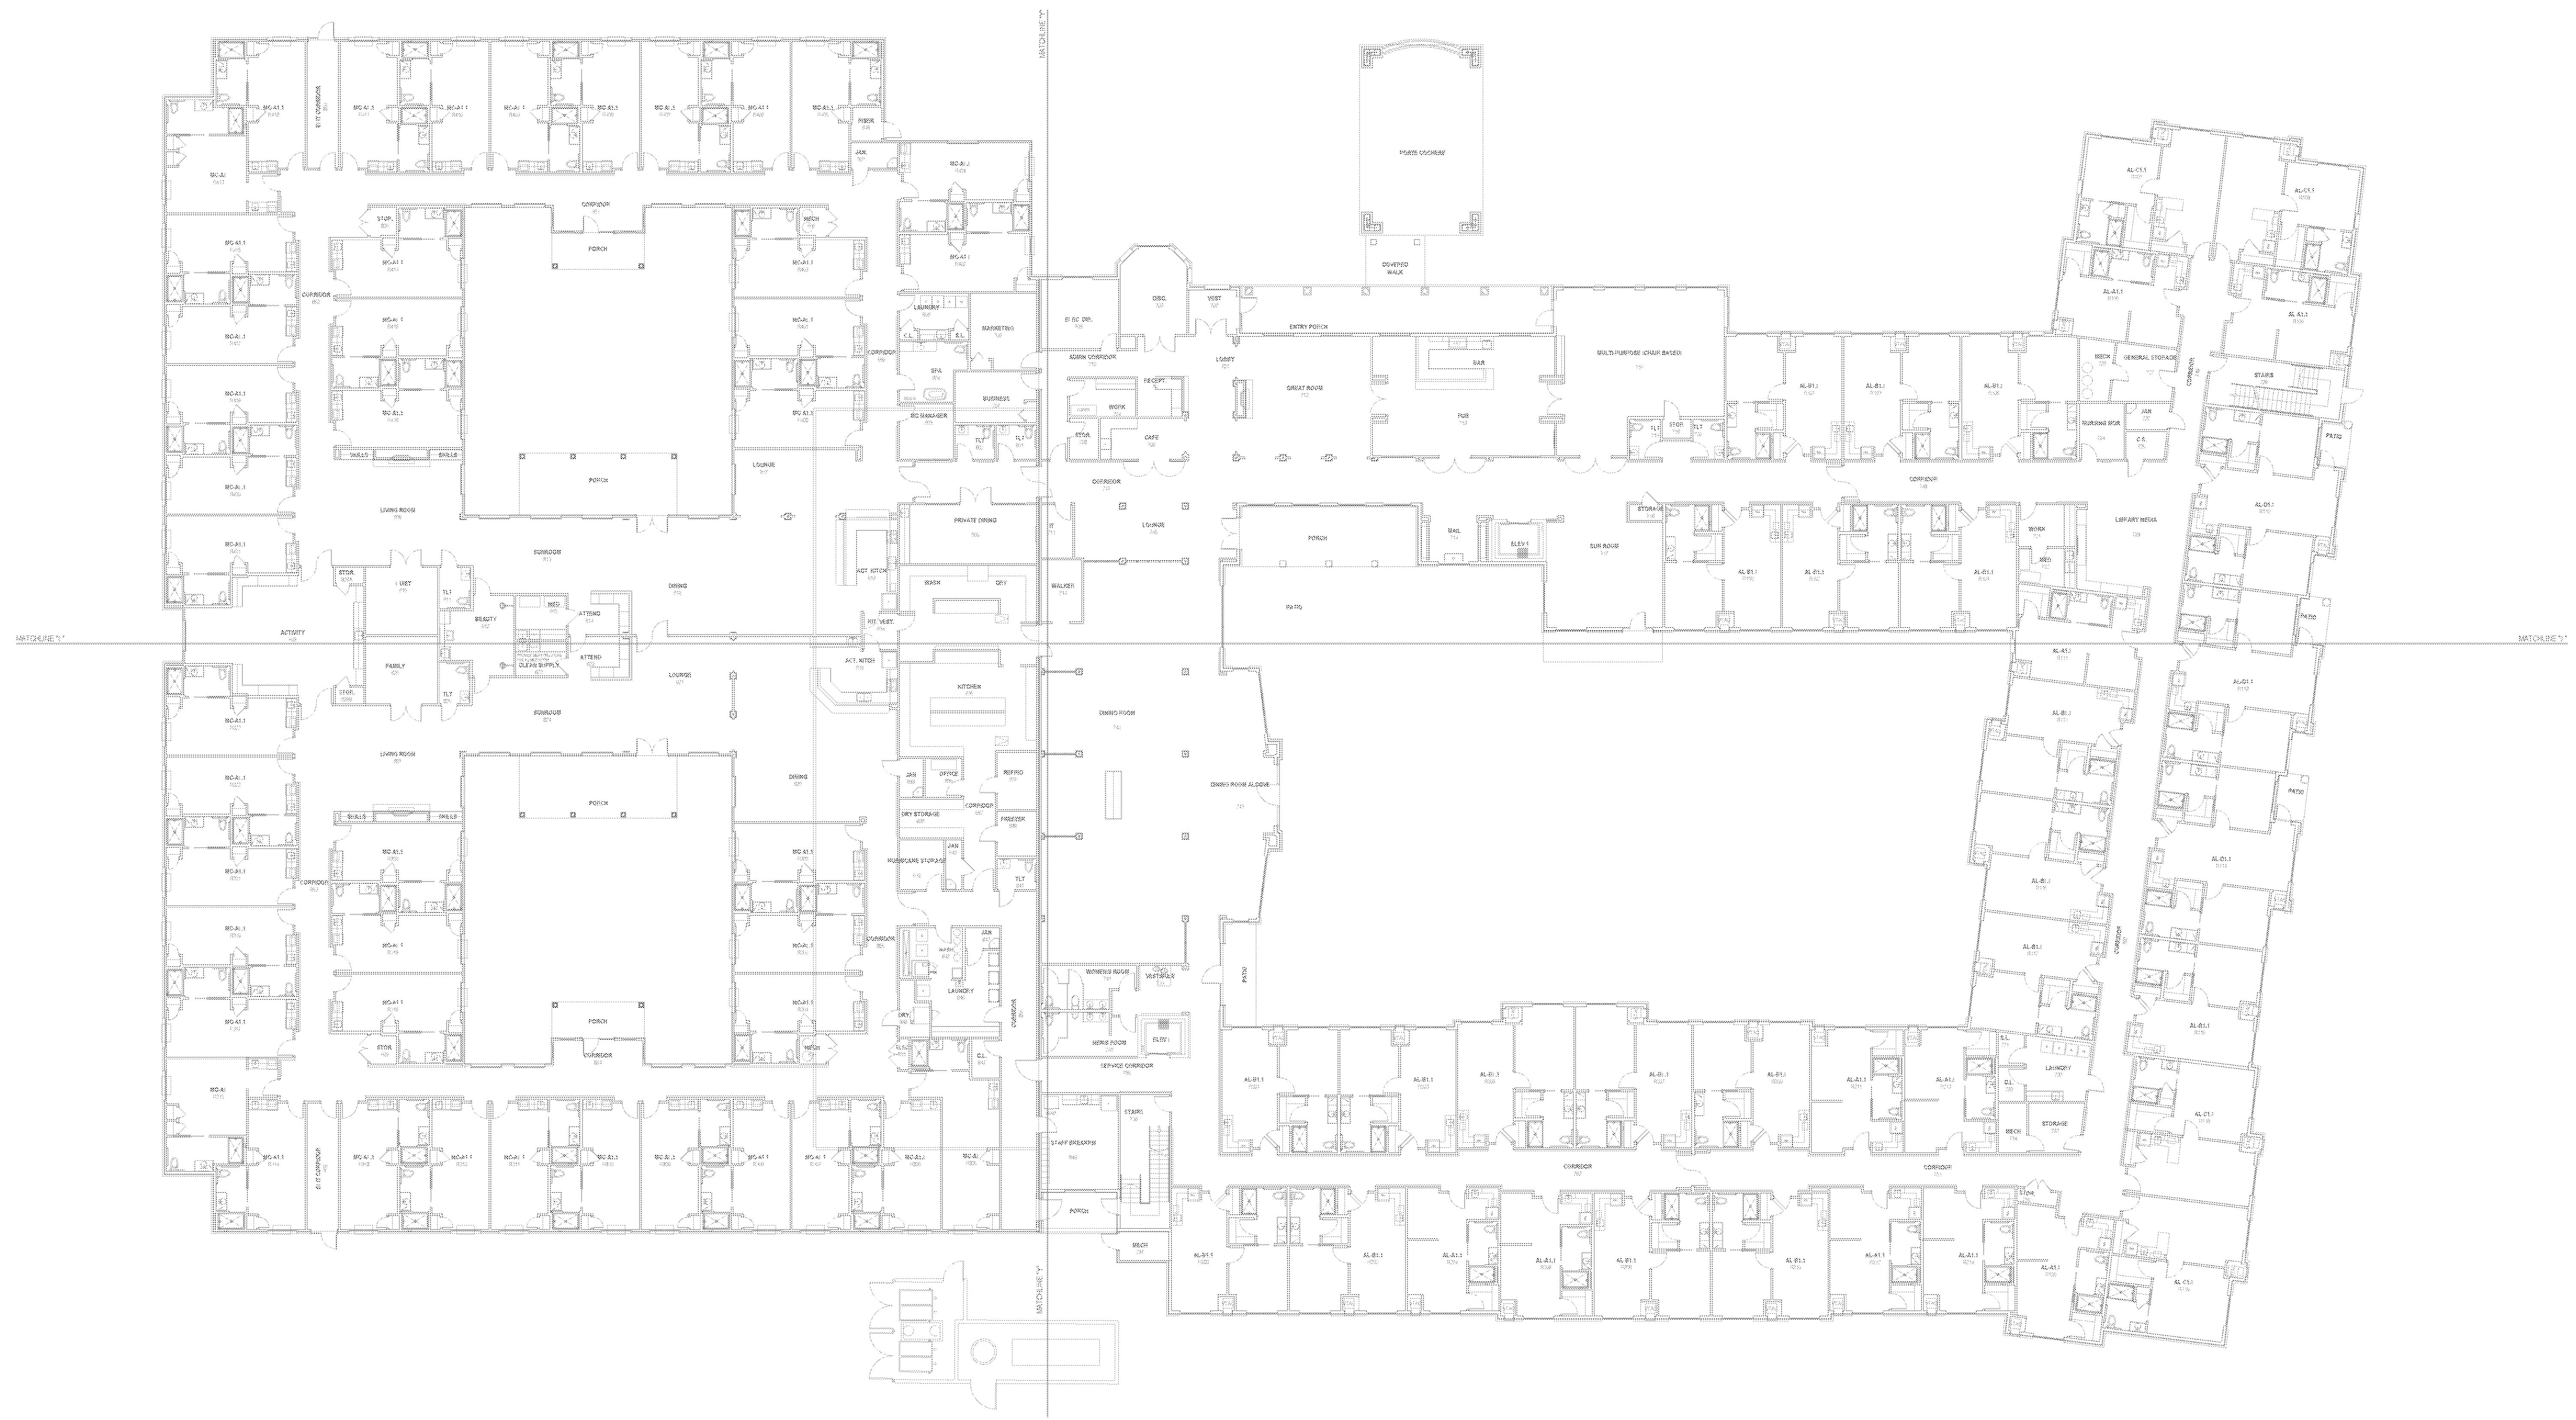

 **1 TELECOM/SECURITY/AV ELECTRONICS
 LEVEL 1 FLOOR PLAN OVERALL**



BIM Server: S:\RV\R2016 - BIM Server 1\14017 Concordis Baton Rouge | Ver. 18.001 | Monday, February 22, 2016 | 1:14 PM