

**WATERSTONE AT BATON ROUGE  
 ASSISTED LIVING & MEMORY CARE**  
 SIEGEN LANE  
 BATON ROUGE, LA 70810


ISSUE: QA  
 CONSTRUCTION  
 DOCUMENTS

©2016 PI ARCHITECTS, INC.


REVISIONS:

DATE: 03/03/2016  
 PROJECT NUMBER: 14017  
 SHEET TITLE: TELECOM/SECURITY/AV ELECTRONICS LEVEL 2 FLOOR PLAN OVERALL

SHEET: T1.2

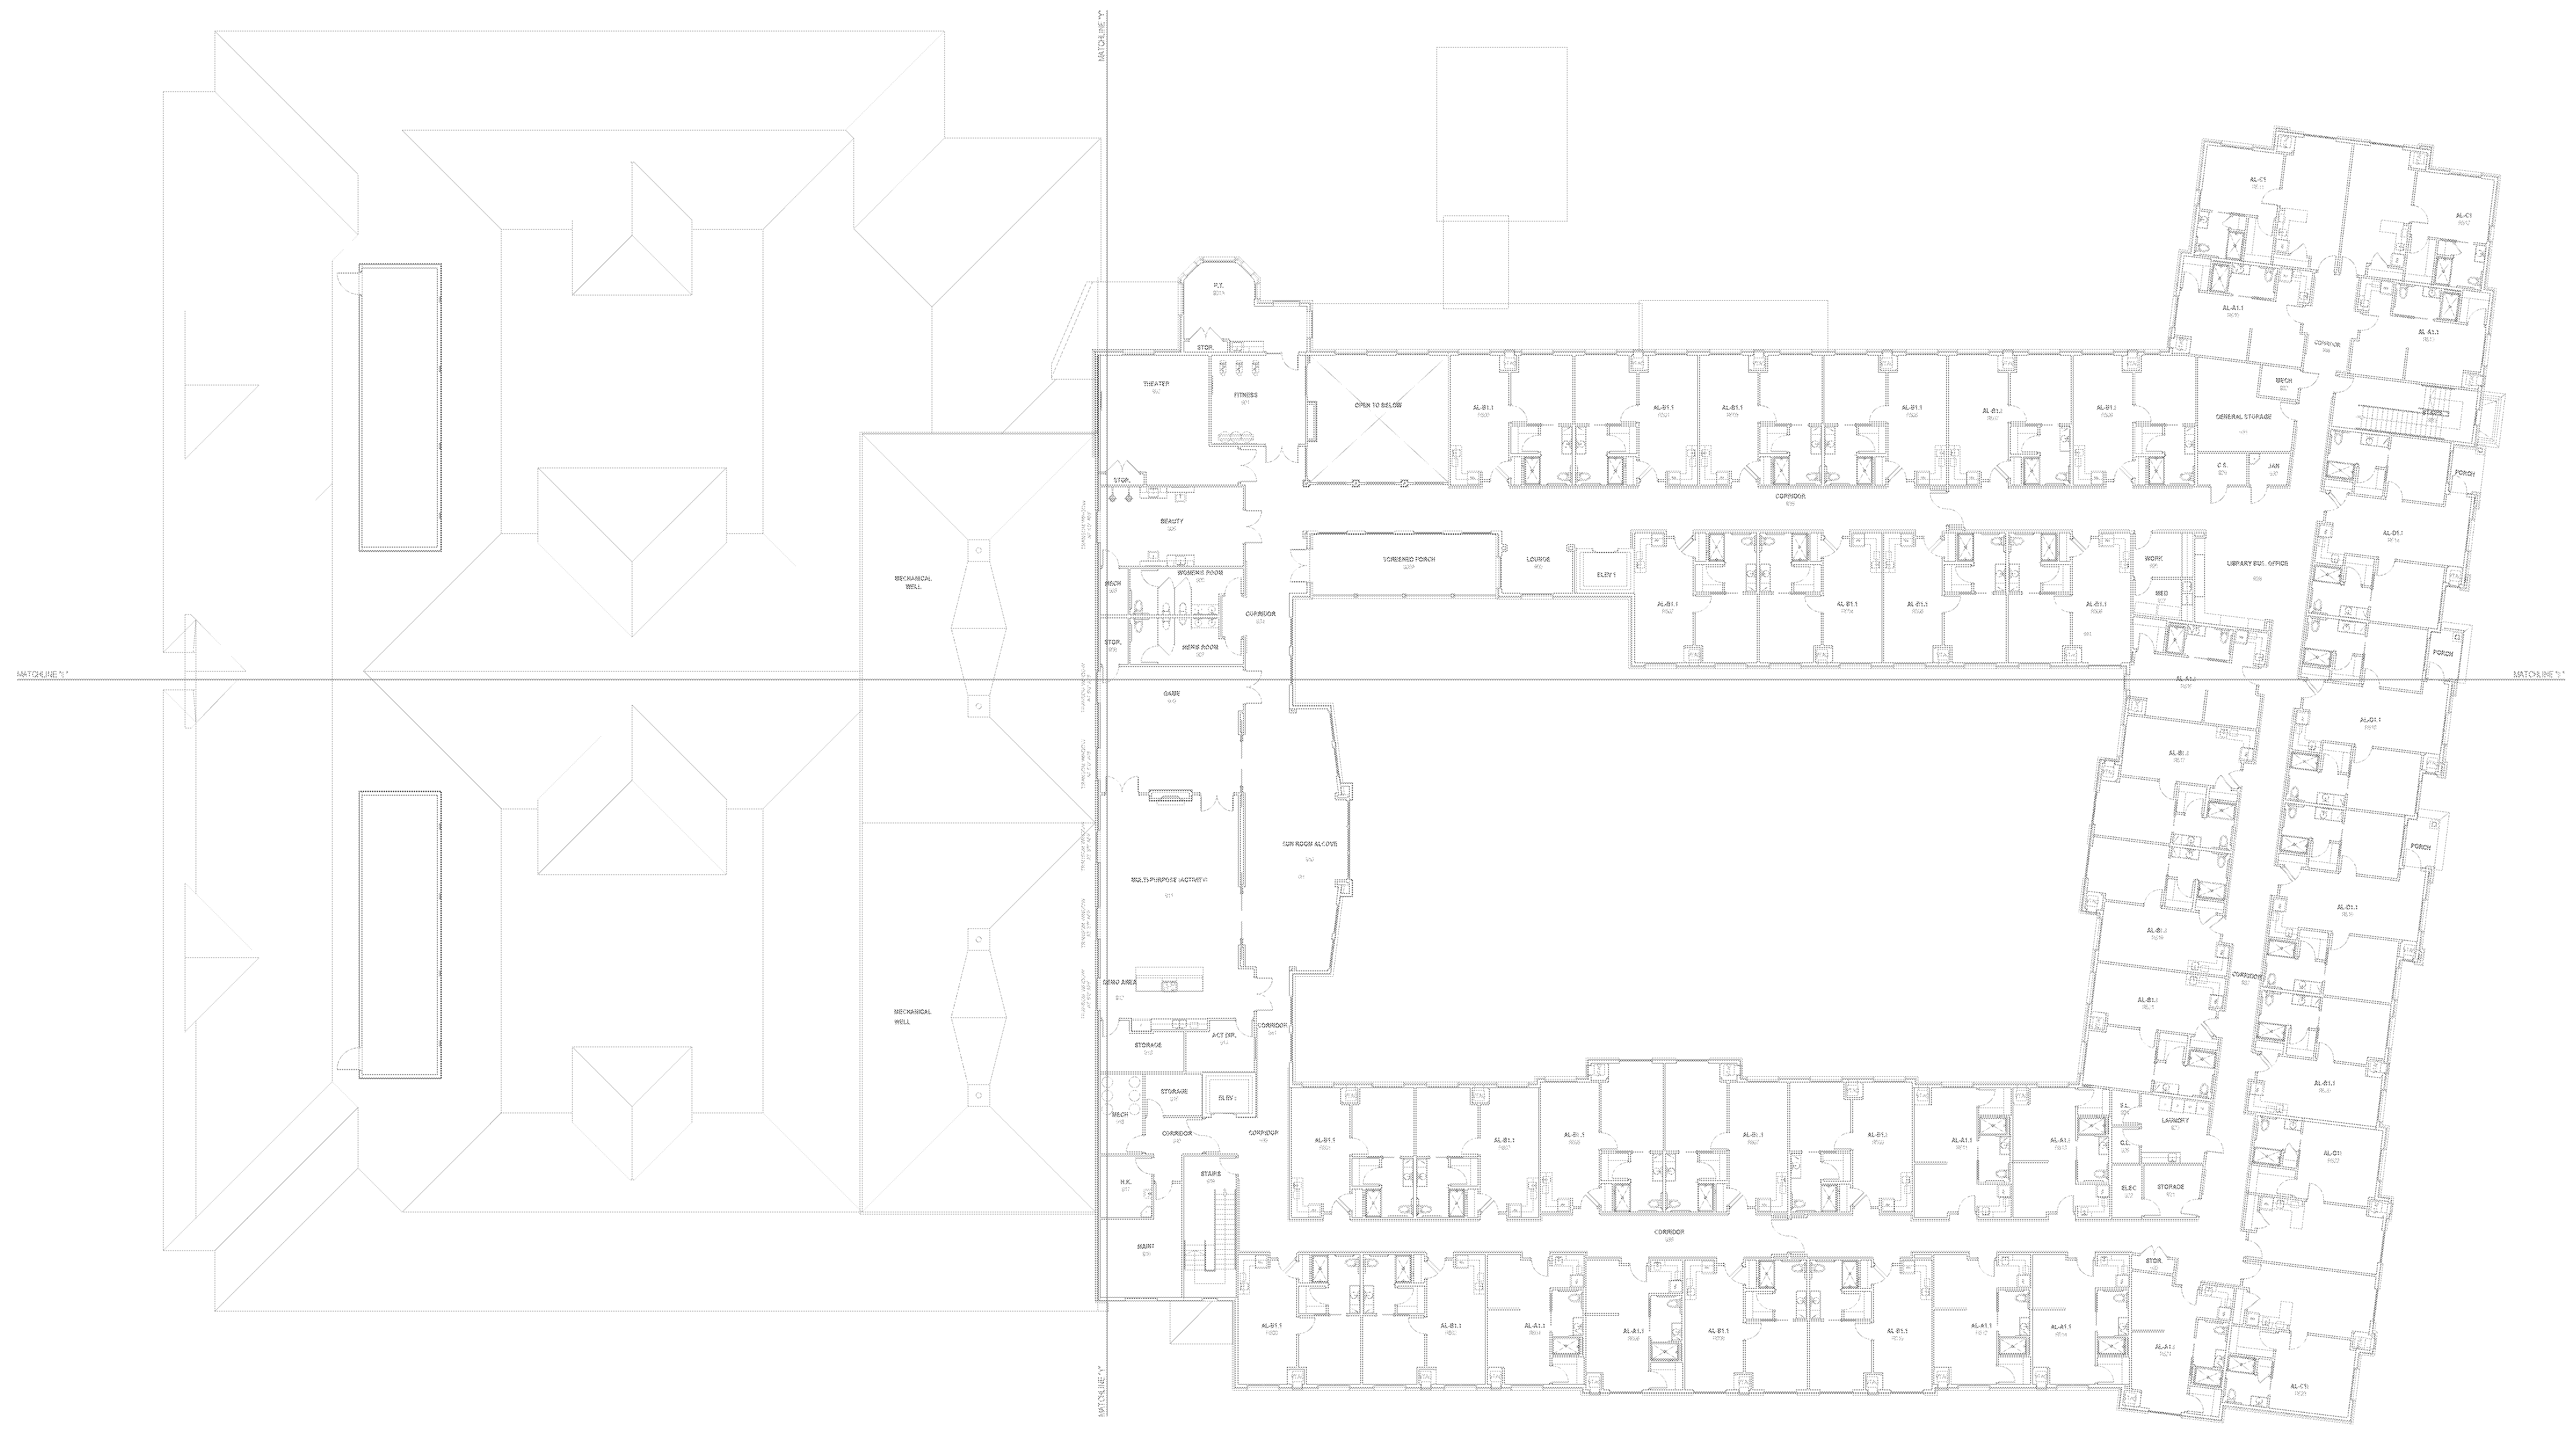

**TELECOM/SECURITY/AV ELECTRONICS  
 LEVEL 2 FLOOR PLAN OVERALL**

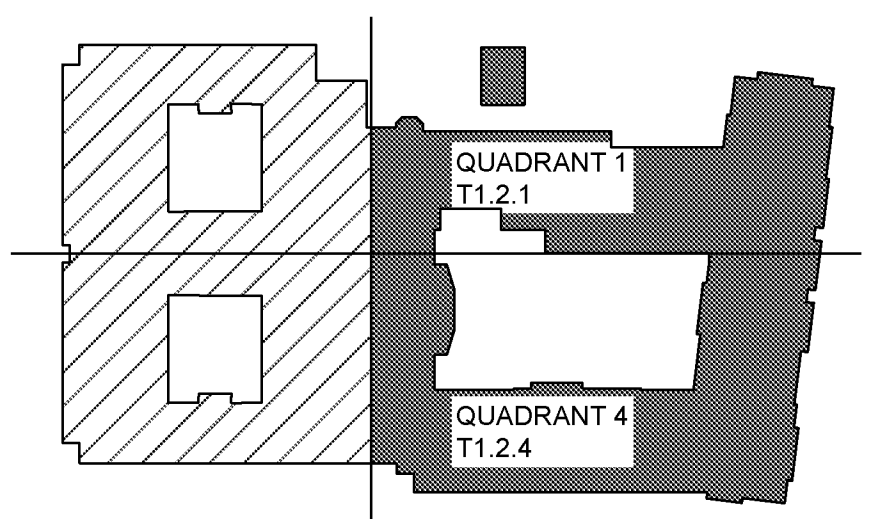

BIM Server: S:\RV\RV2016 - BIM Server\1\14017 Concordia Baton Rouge | Ver. 18.001 | Monday, February 22, 2016 | 11:14 AM