



pi architects

3500 Jefferson St., Suite 303  
Austin, TX 78731

P: (512) 231-1910  
F: (512) 231-1950

www.piarch.com

architecture + master  
interior + landscape  
architecture

GUIDEPPOST SOLUTIONS LLC  
2800 North Dallas Parkway, Suite 300  
Plano, TX 75093  
Office: (469) 569-0300  
Website: www.guidepostsolutions.com

# WATERSTONE AT BATON ROUGE ASSISTED LIVING & MEMORY CARE

SIEGEN LANE  
BATON ROUGE, LA 70810

ISSUE: QA  
CONSTRUCTION  
DOCUMENTS

©2016 PI ARCHITECTS, INC.

REVISIONS:


DATE: 03/03/2016

PROJECT NUMBER: 14017



SHEET TITLE: TELECOM/SECURITY/AV  
ELECTRONICS  
LEVEL 1 FLOOR PLAN  
(NW)

SHEET:

T1.1.2

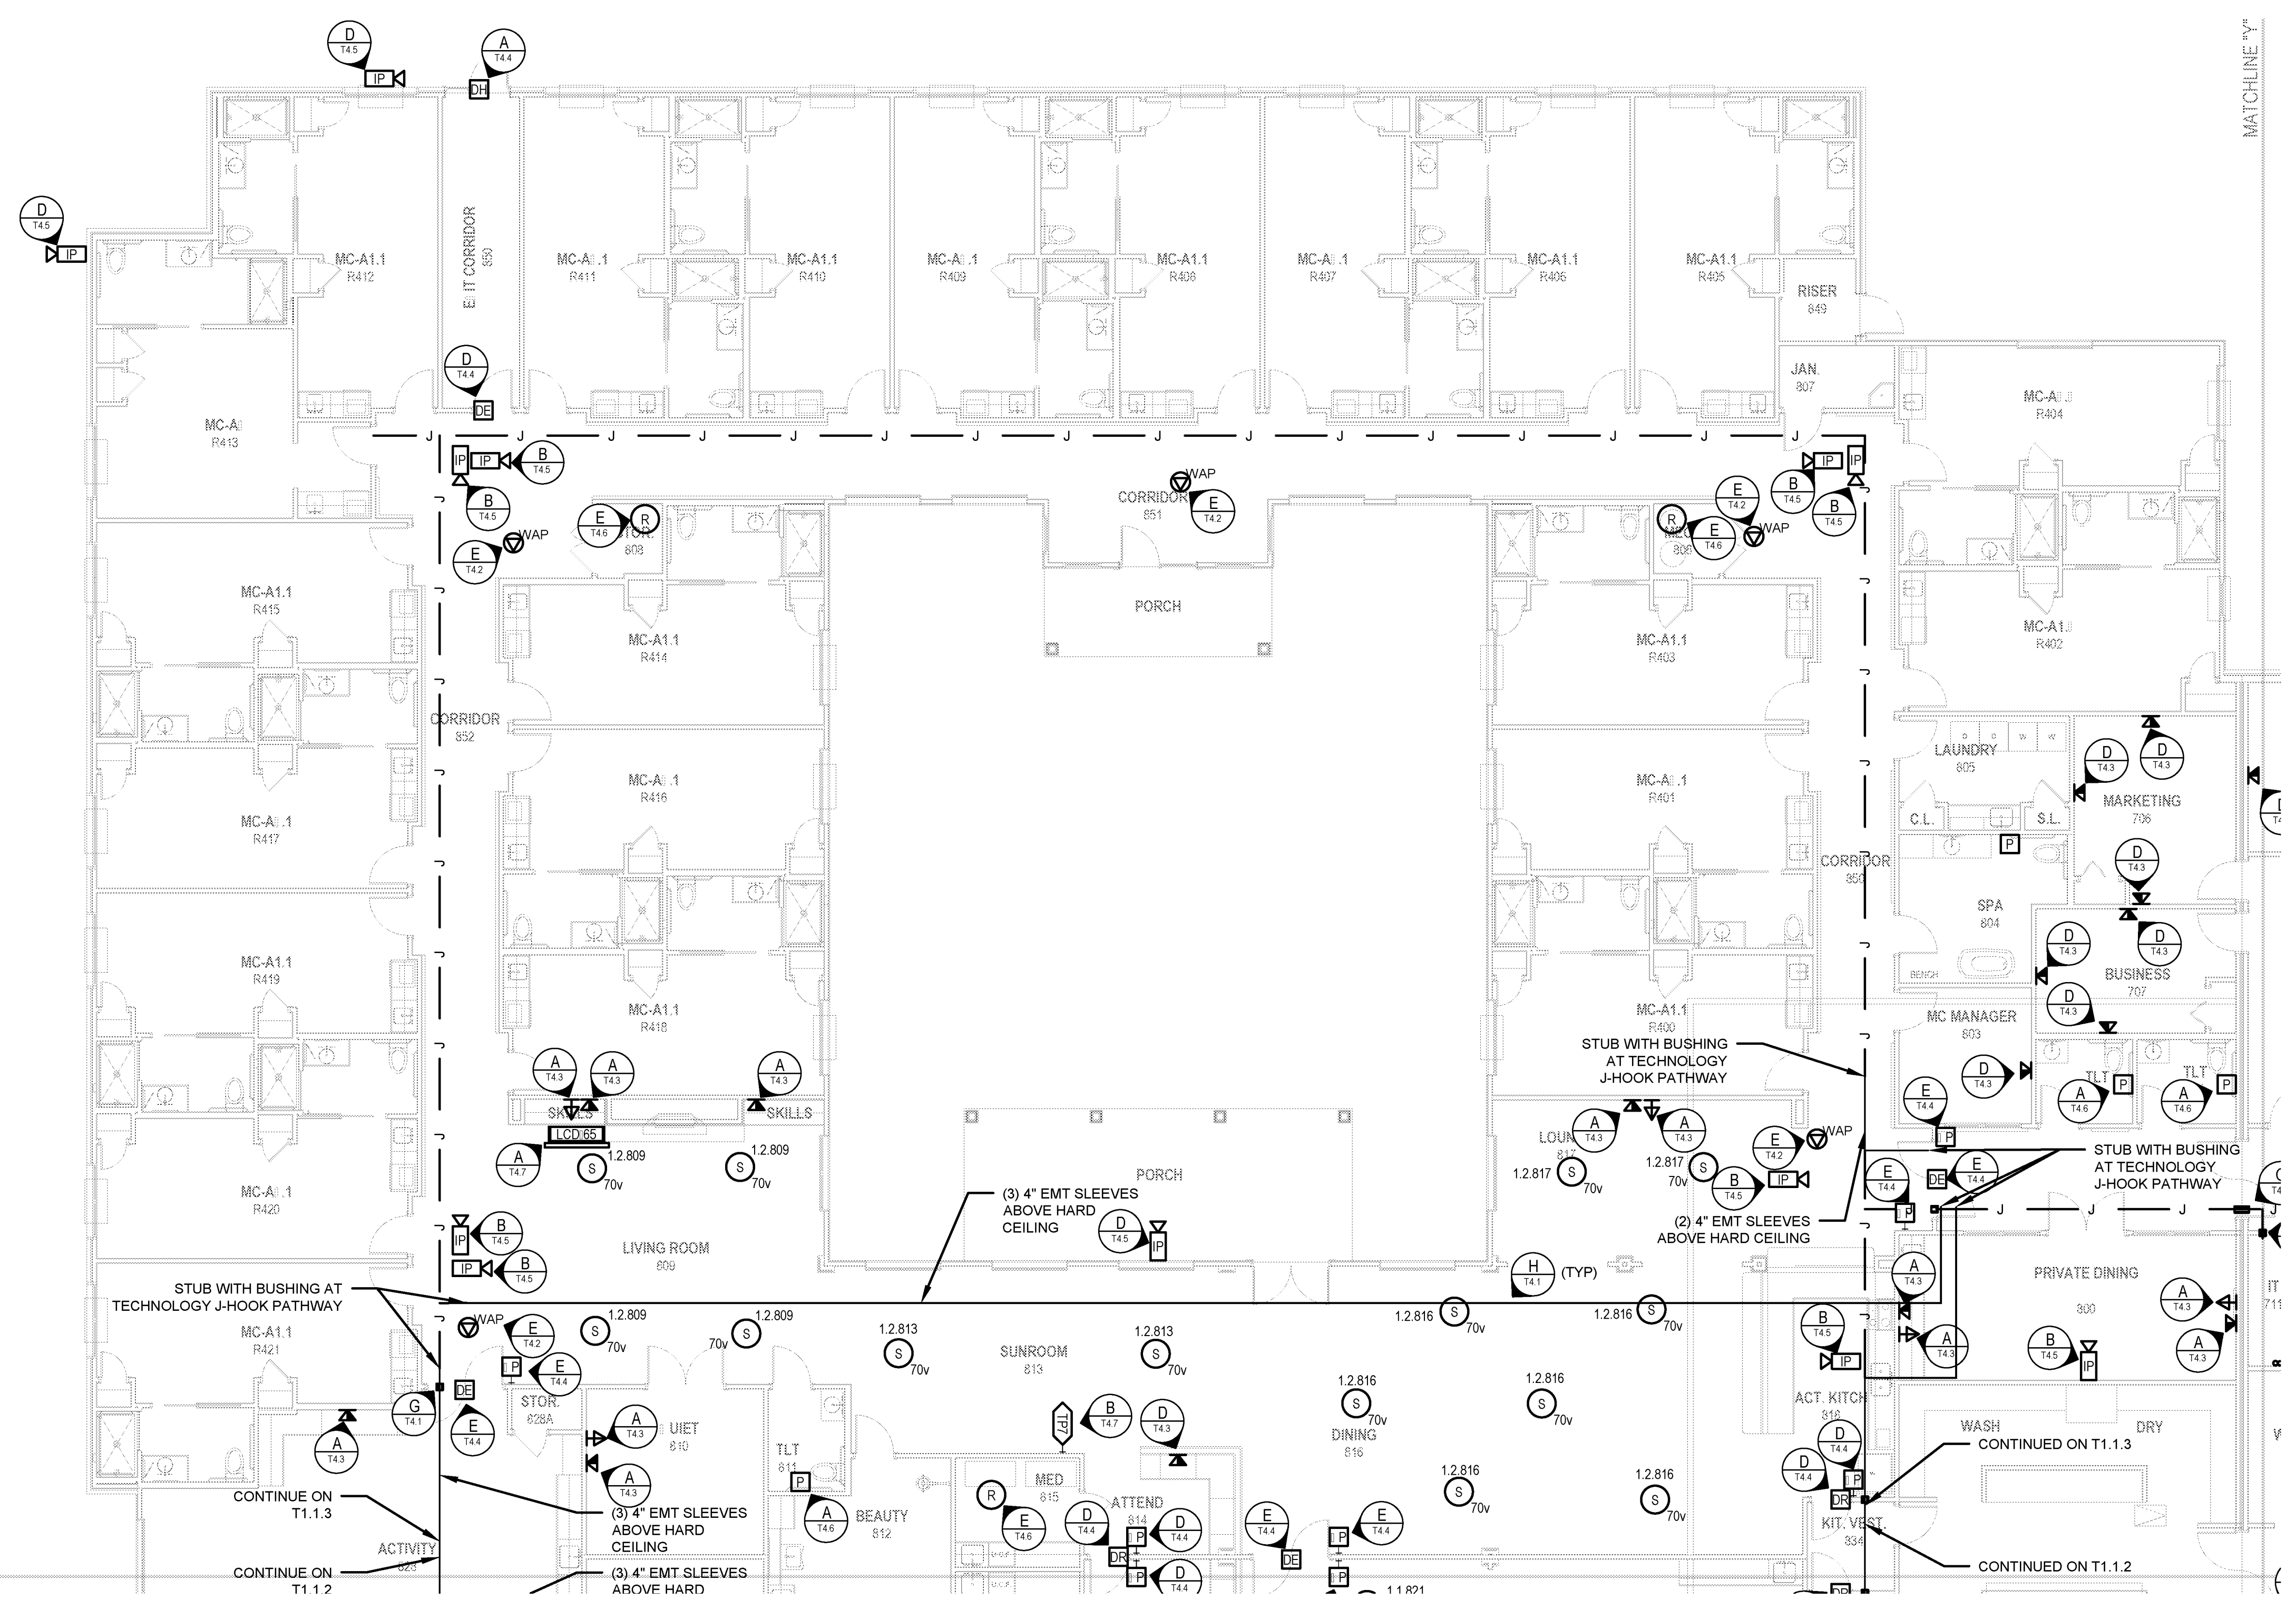

 **TELECOM/SECURITY/AV ELECTRONICS  
LEVEL 1 FLOOR PLAN (NW)**

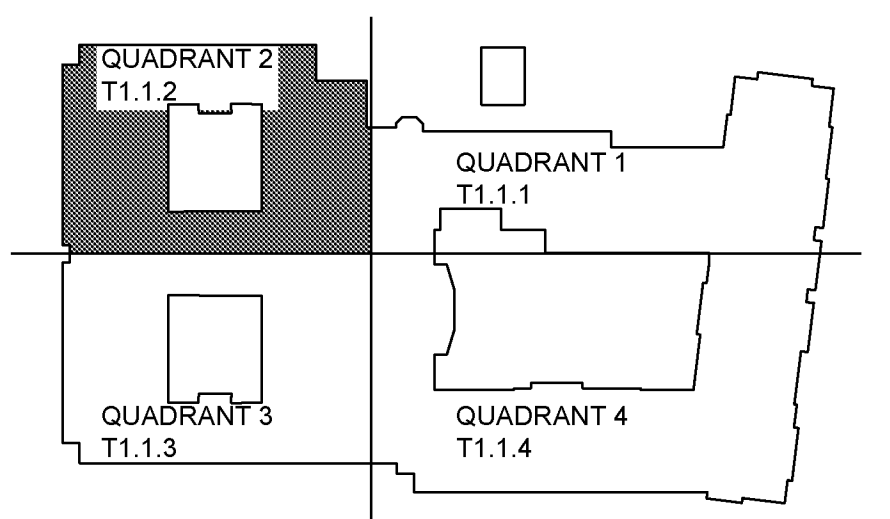

BIM Server: S:\RV\R2015 - BIM Server\1\14017 Concordia Baton Rouge\1\Ver. 18.001\Monday, February 22, 2016 11:44 AM