

**WATERSTONE AT BATON ROUGE  
 ASSISTED LIVING & MEMORY CARE**  
 SIEGEN LANE  
 BATON ROUGE, LA 70810


ISSUE: QA  
 CONSTRUCTION DOCUMENTS

©2016 PI ARCHITECTS, INC.



REVISIONS:

DATE: 03/03/2016  
 PROJECT NUMBER: 14017  
 SHEET TITLE: TELECOM/SECURITY/AV ELECTRONICS LEVEL 1 FLOOR PLAN (SW)

SHEET: T1.1.3

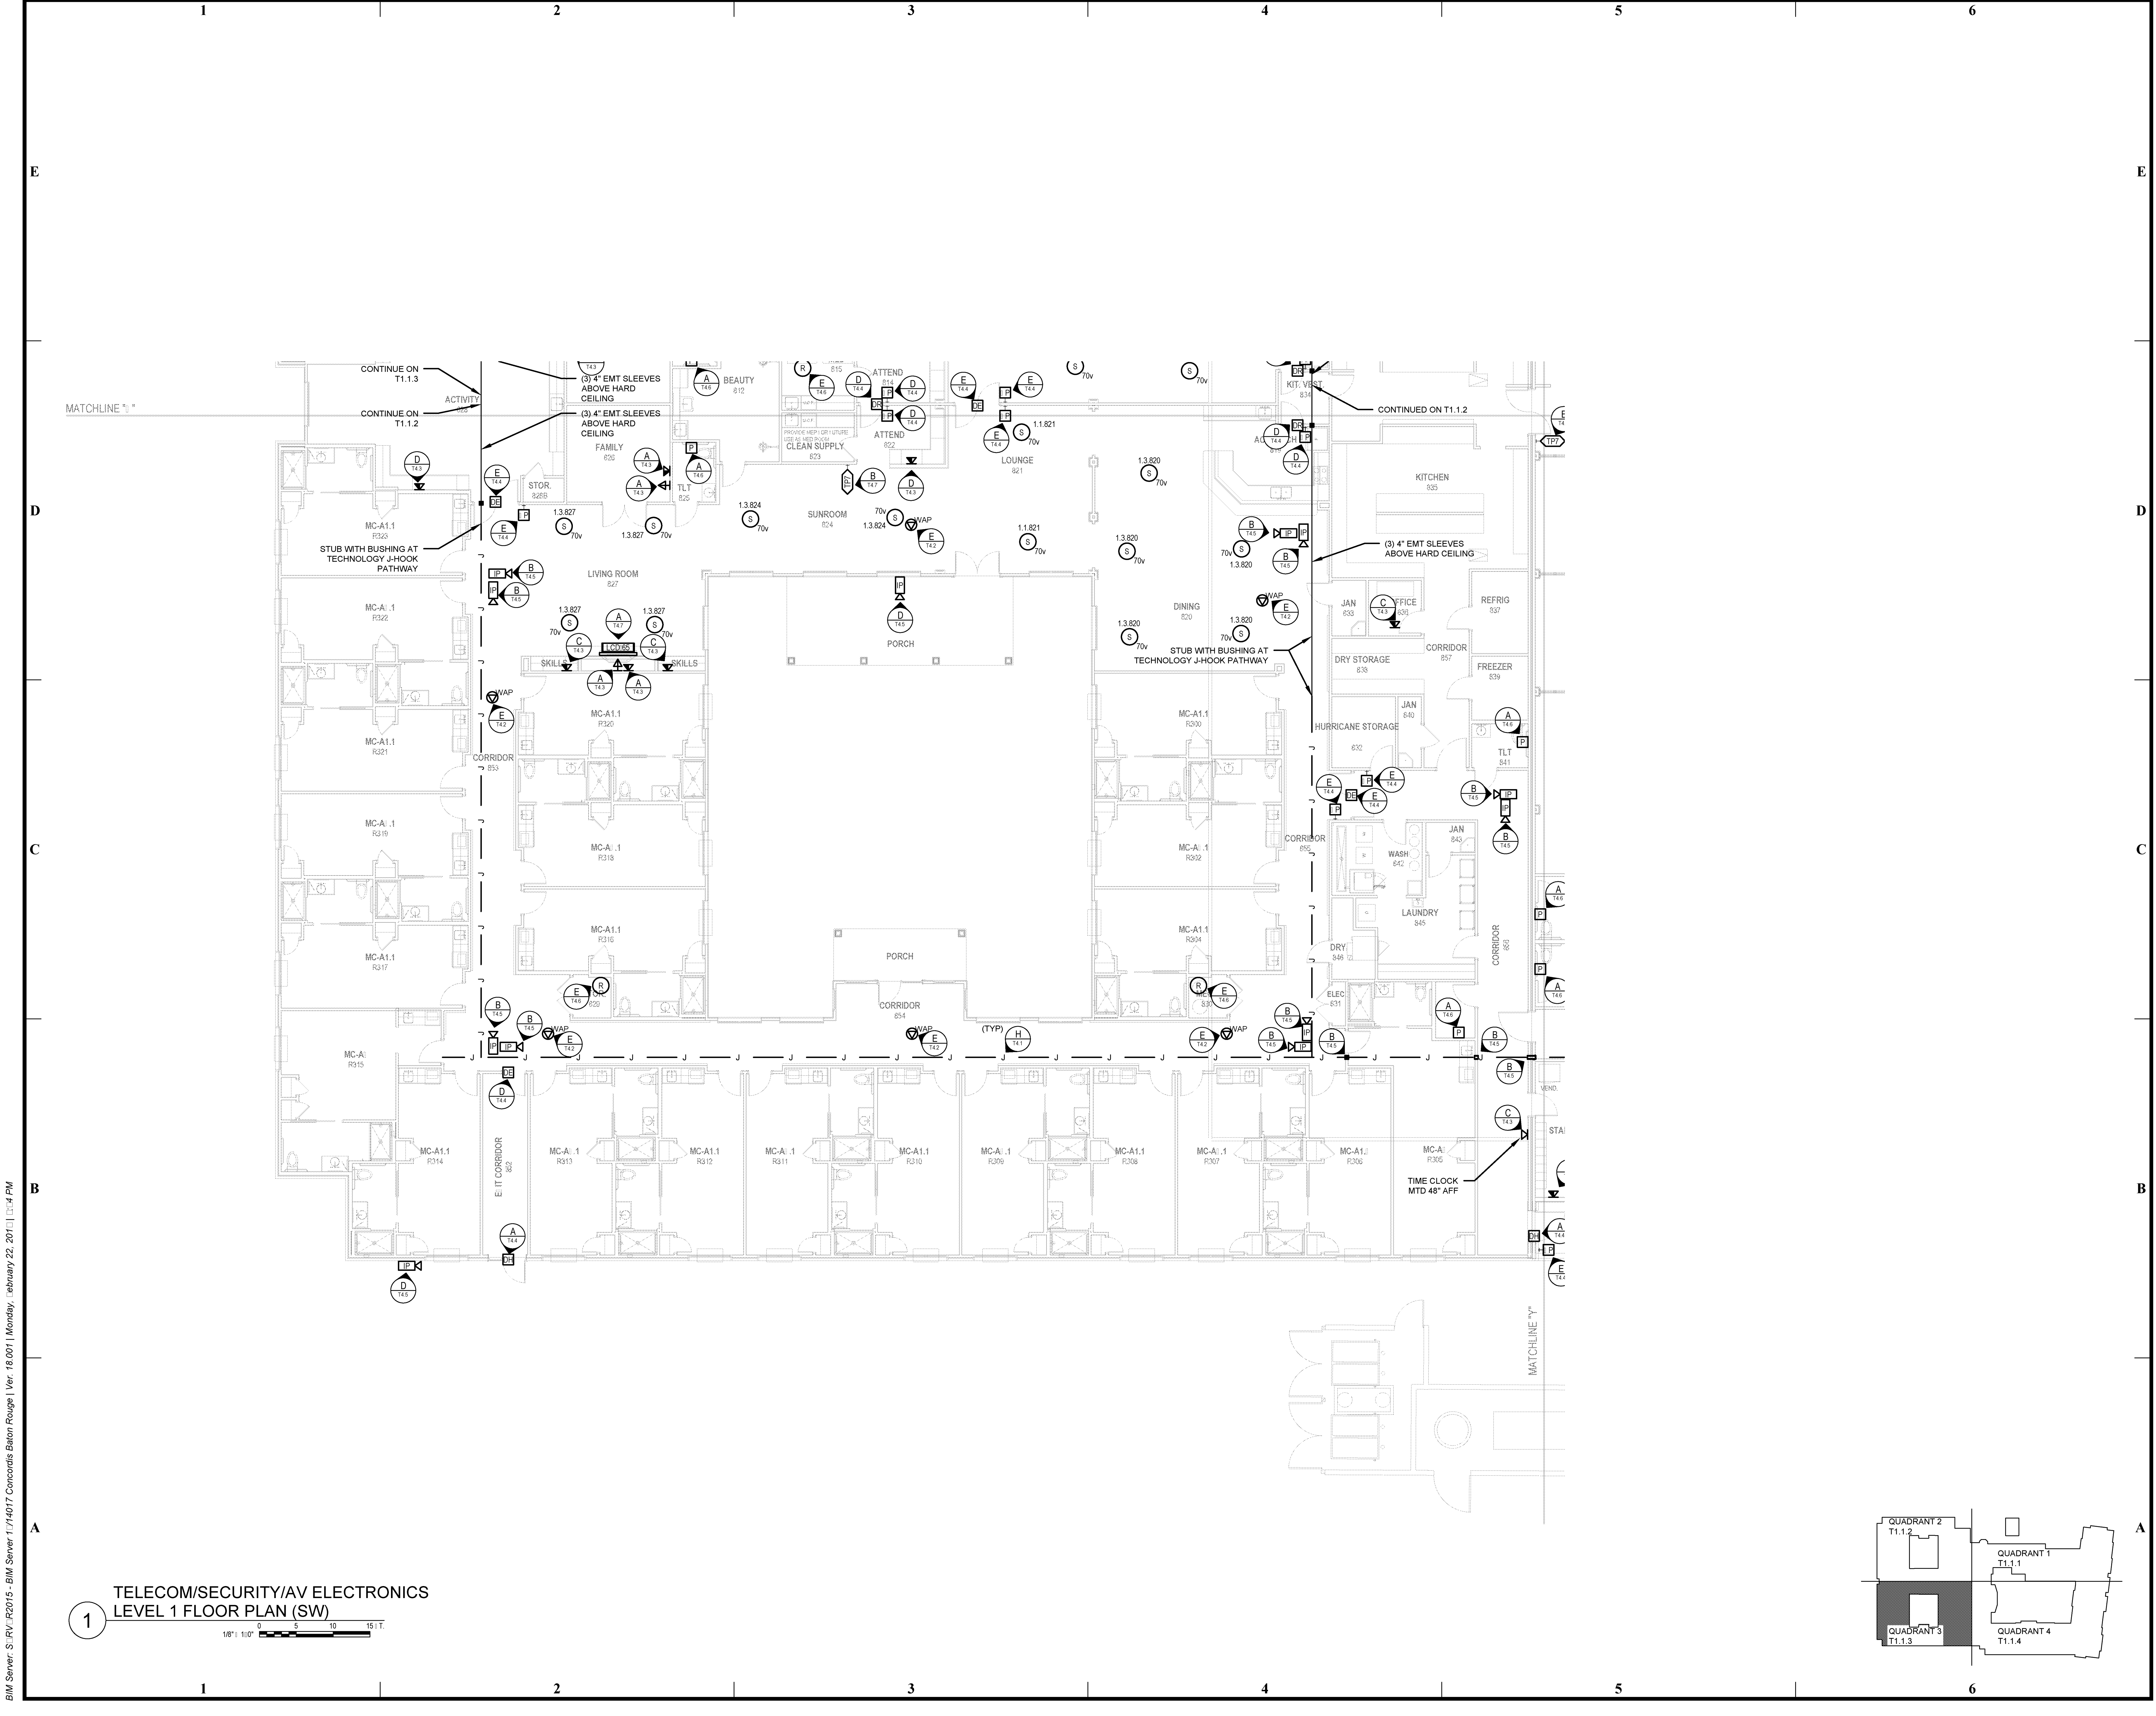

 **TELECOM/SECURITY/AV ELECTRONICS  
 LEVEL 1 FLOOR PLAN (SW)**

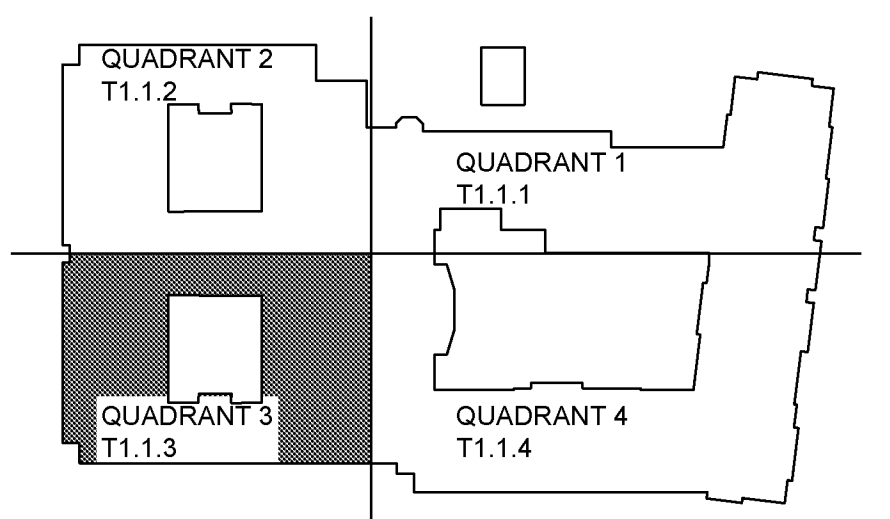

BIM Server: S:\RV\RV2015 - BIM Server\1\14017 Concordis Baton Rouge\Ver. 18.001\Monday, February 22, 2016 1:14 PM