

**WATERSTONE AT BATON ROUGE
 ASSISTED LIVING & MEMORY CARE**

SIEGEN LANE
 BATON ROUGE, LA 70810


ISSUE: QA
 CONSTRUCTION
 DOCUMENTS

©2016 PI ARCHITECTS, INC.



REVISIONS:

DATE: 03/03/2016
 PROJECT NUMBER: 14017
 SHEET TITLE: TELECOM/SECURITY/AV ELECTRONICS LEVEL 1 FLOOR PLAN (SE)

SHEET: T1.1.4

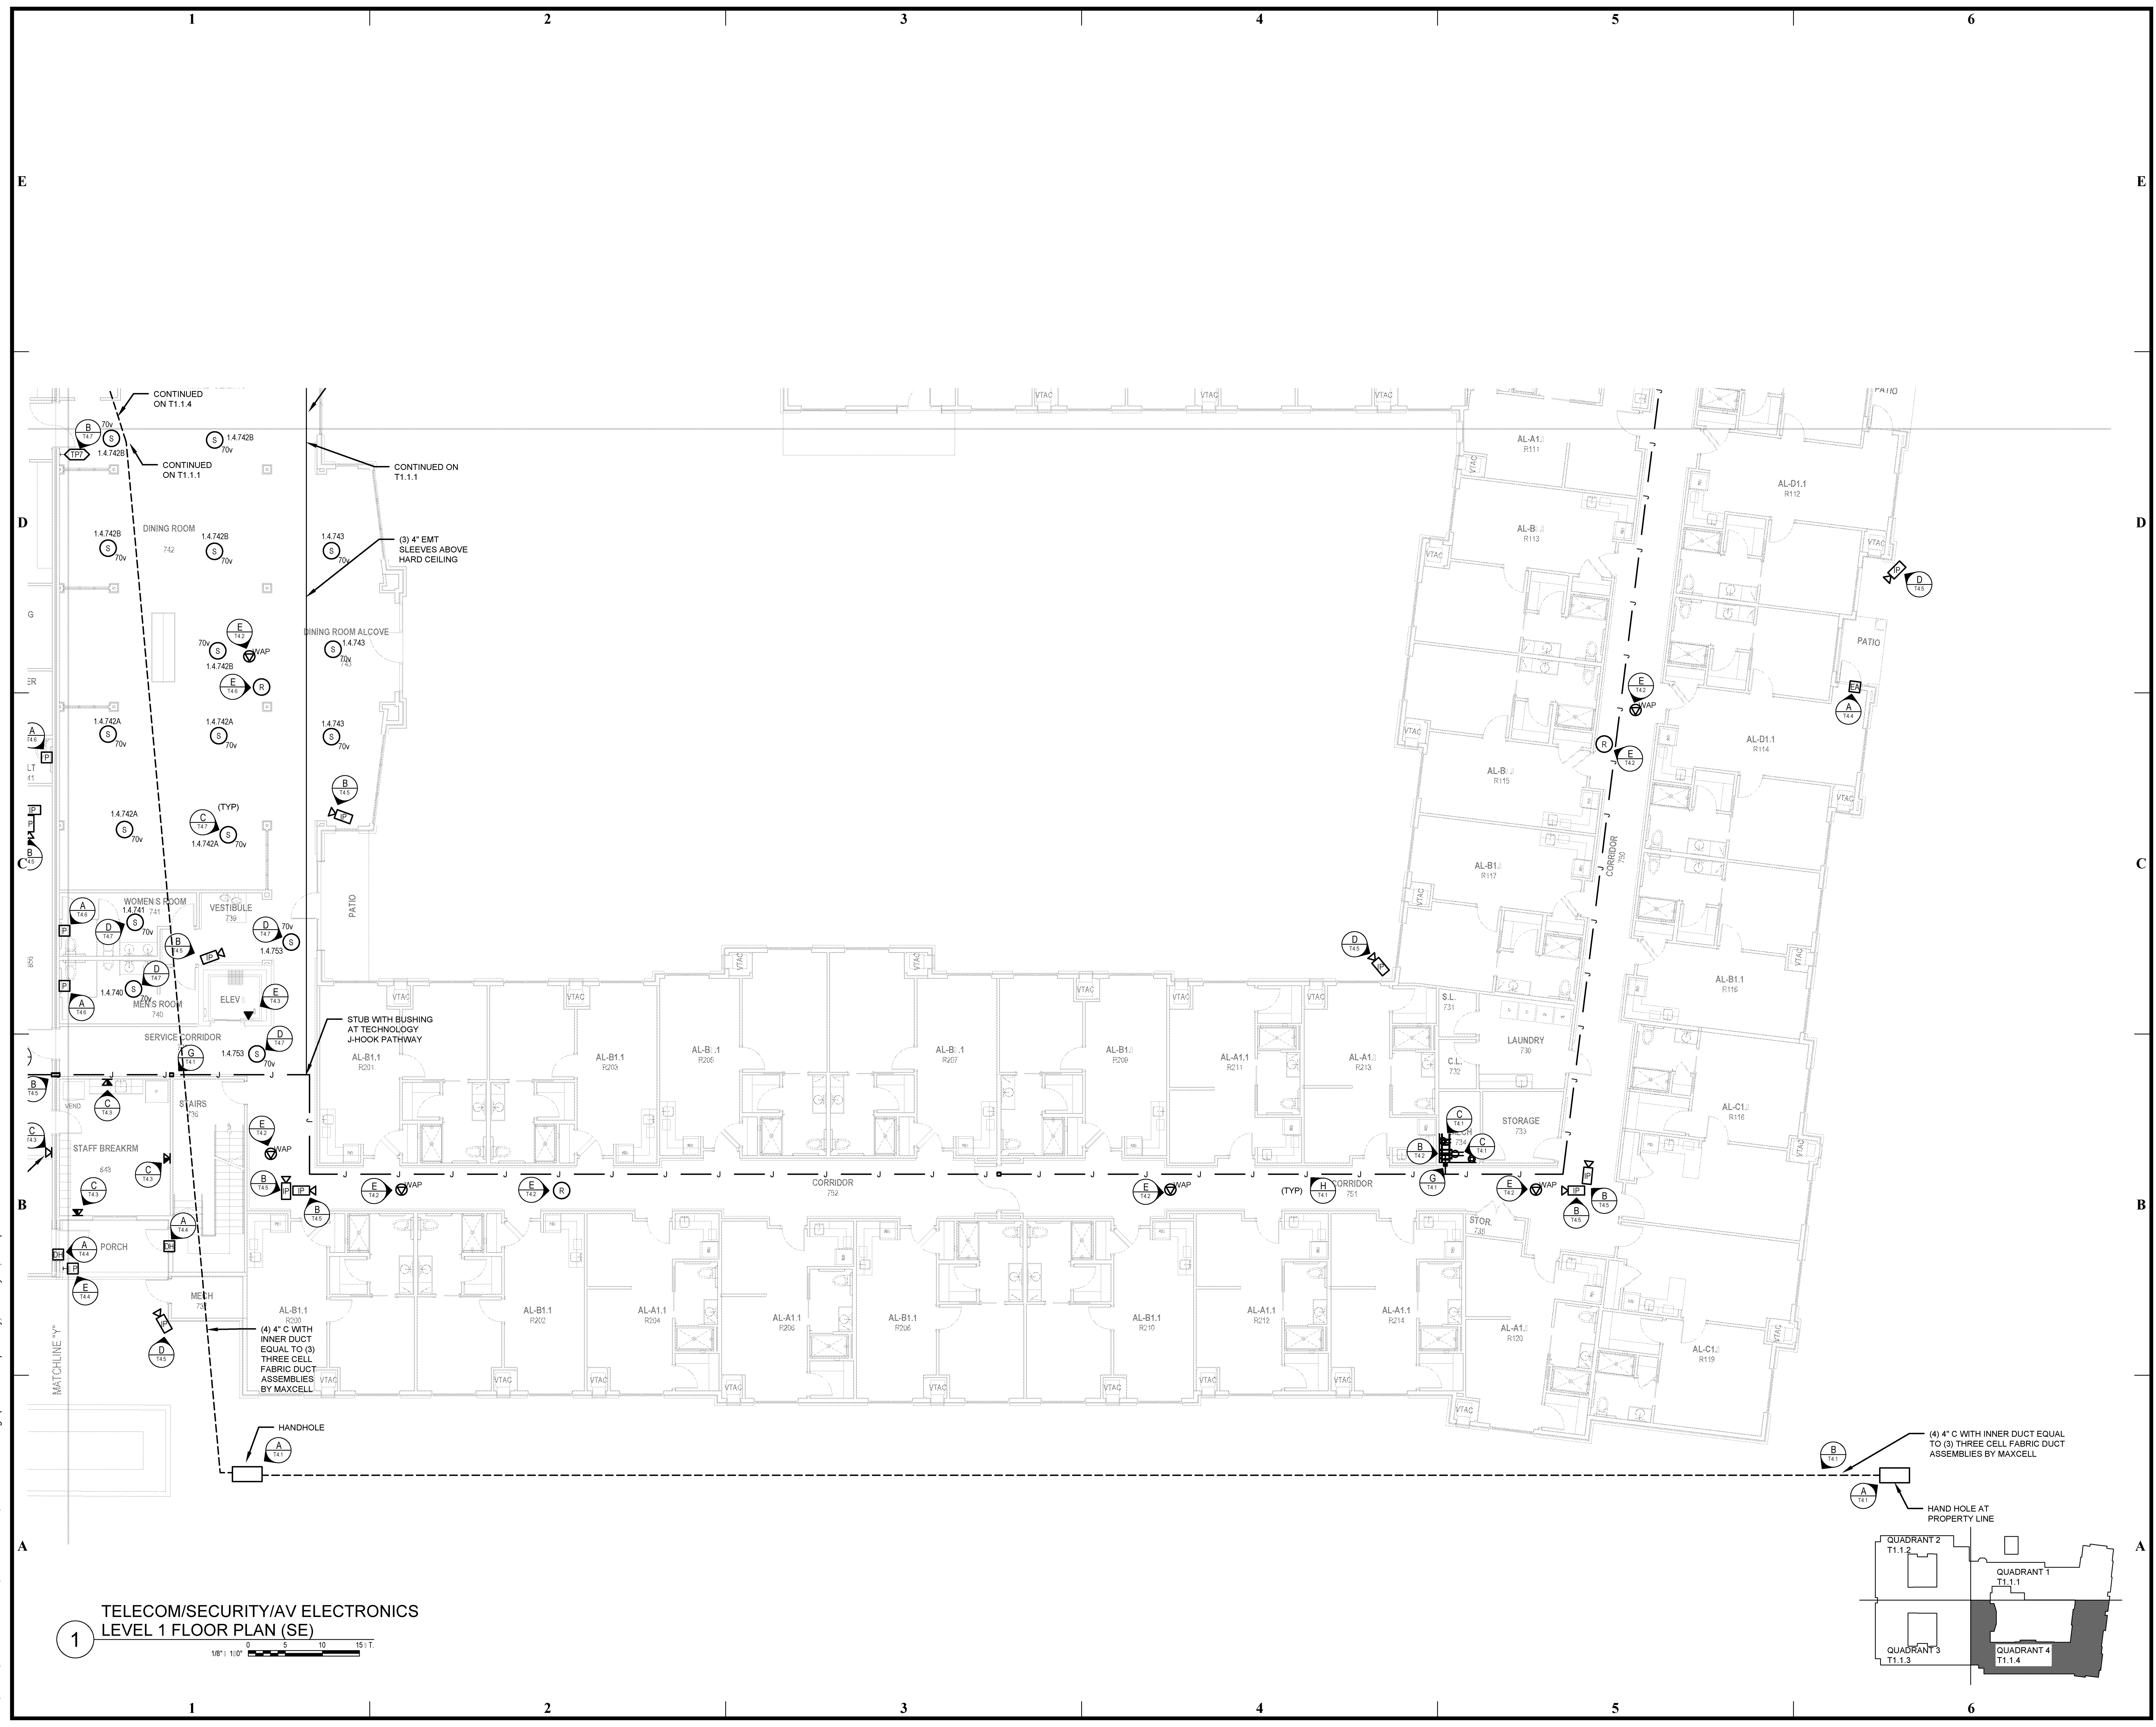

 **1 TELECOM/SECURITY/AV ELECTRONICS
 LEVEL 1 FLOOR PLAN (SE)**

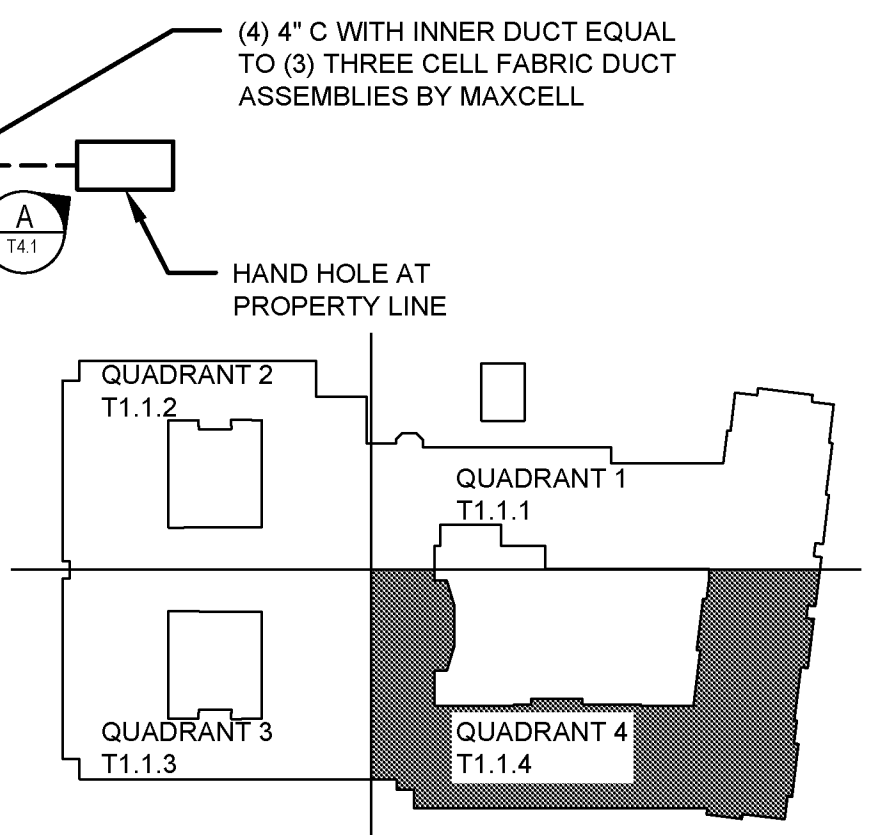

BIM Server: S:\RV\RV2015 - BIM Server\1\14017 Concordia Baton Rouge\ Ver. 18.001\Monday, February 22, 2016 11:14 PM