

KEYNOTES:

- (2) 1-1/4" C STUBBED TO LADDER RACK IN IT ROOM 311 BELOW.
- (2) 1-1/4" C STUBBED TO WEATHERHEAD ON ROOF ABOVE.

**WATERSTONE AT BATON ROUGE
 ASSISTED LIVING & MEMORY CARE**

SIEGEN LANE
 BATON ROUGE, LA 70810

ISSUE: QA
 CONSTRUCTION DOCUMENTS


©2016 PI ARCHITECTS, INC.

REVISIONS:

NO.	DATE	DESCRIPTION

DATE: 03/03/2016
 PROJECT NUMBER: 14017
 SHEET TITLE: TELECOM/SECURITY/AV ELECTRONICS LEVEL 2 FLOOR PLAN (NE)

SHEET: T1.2.1

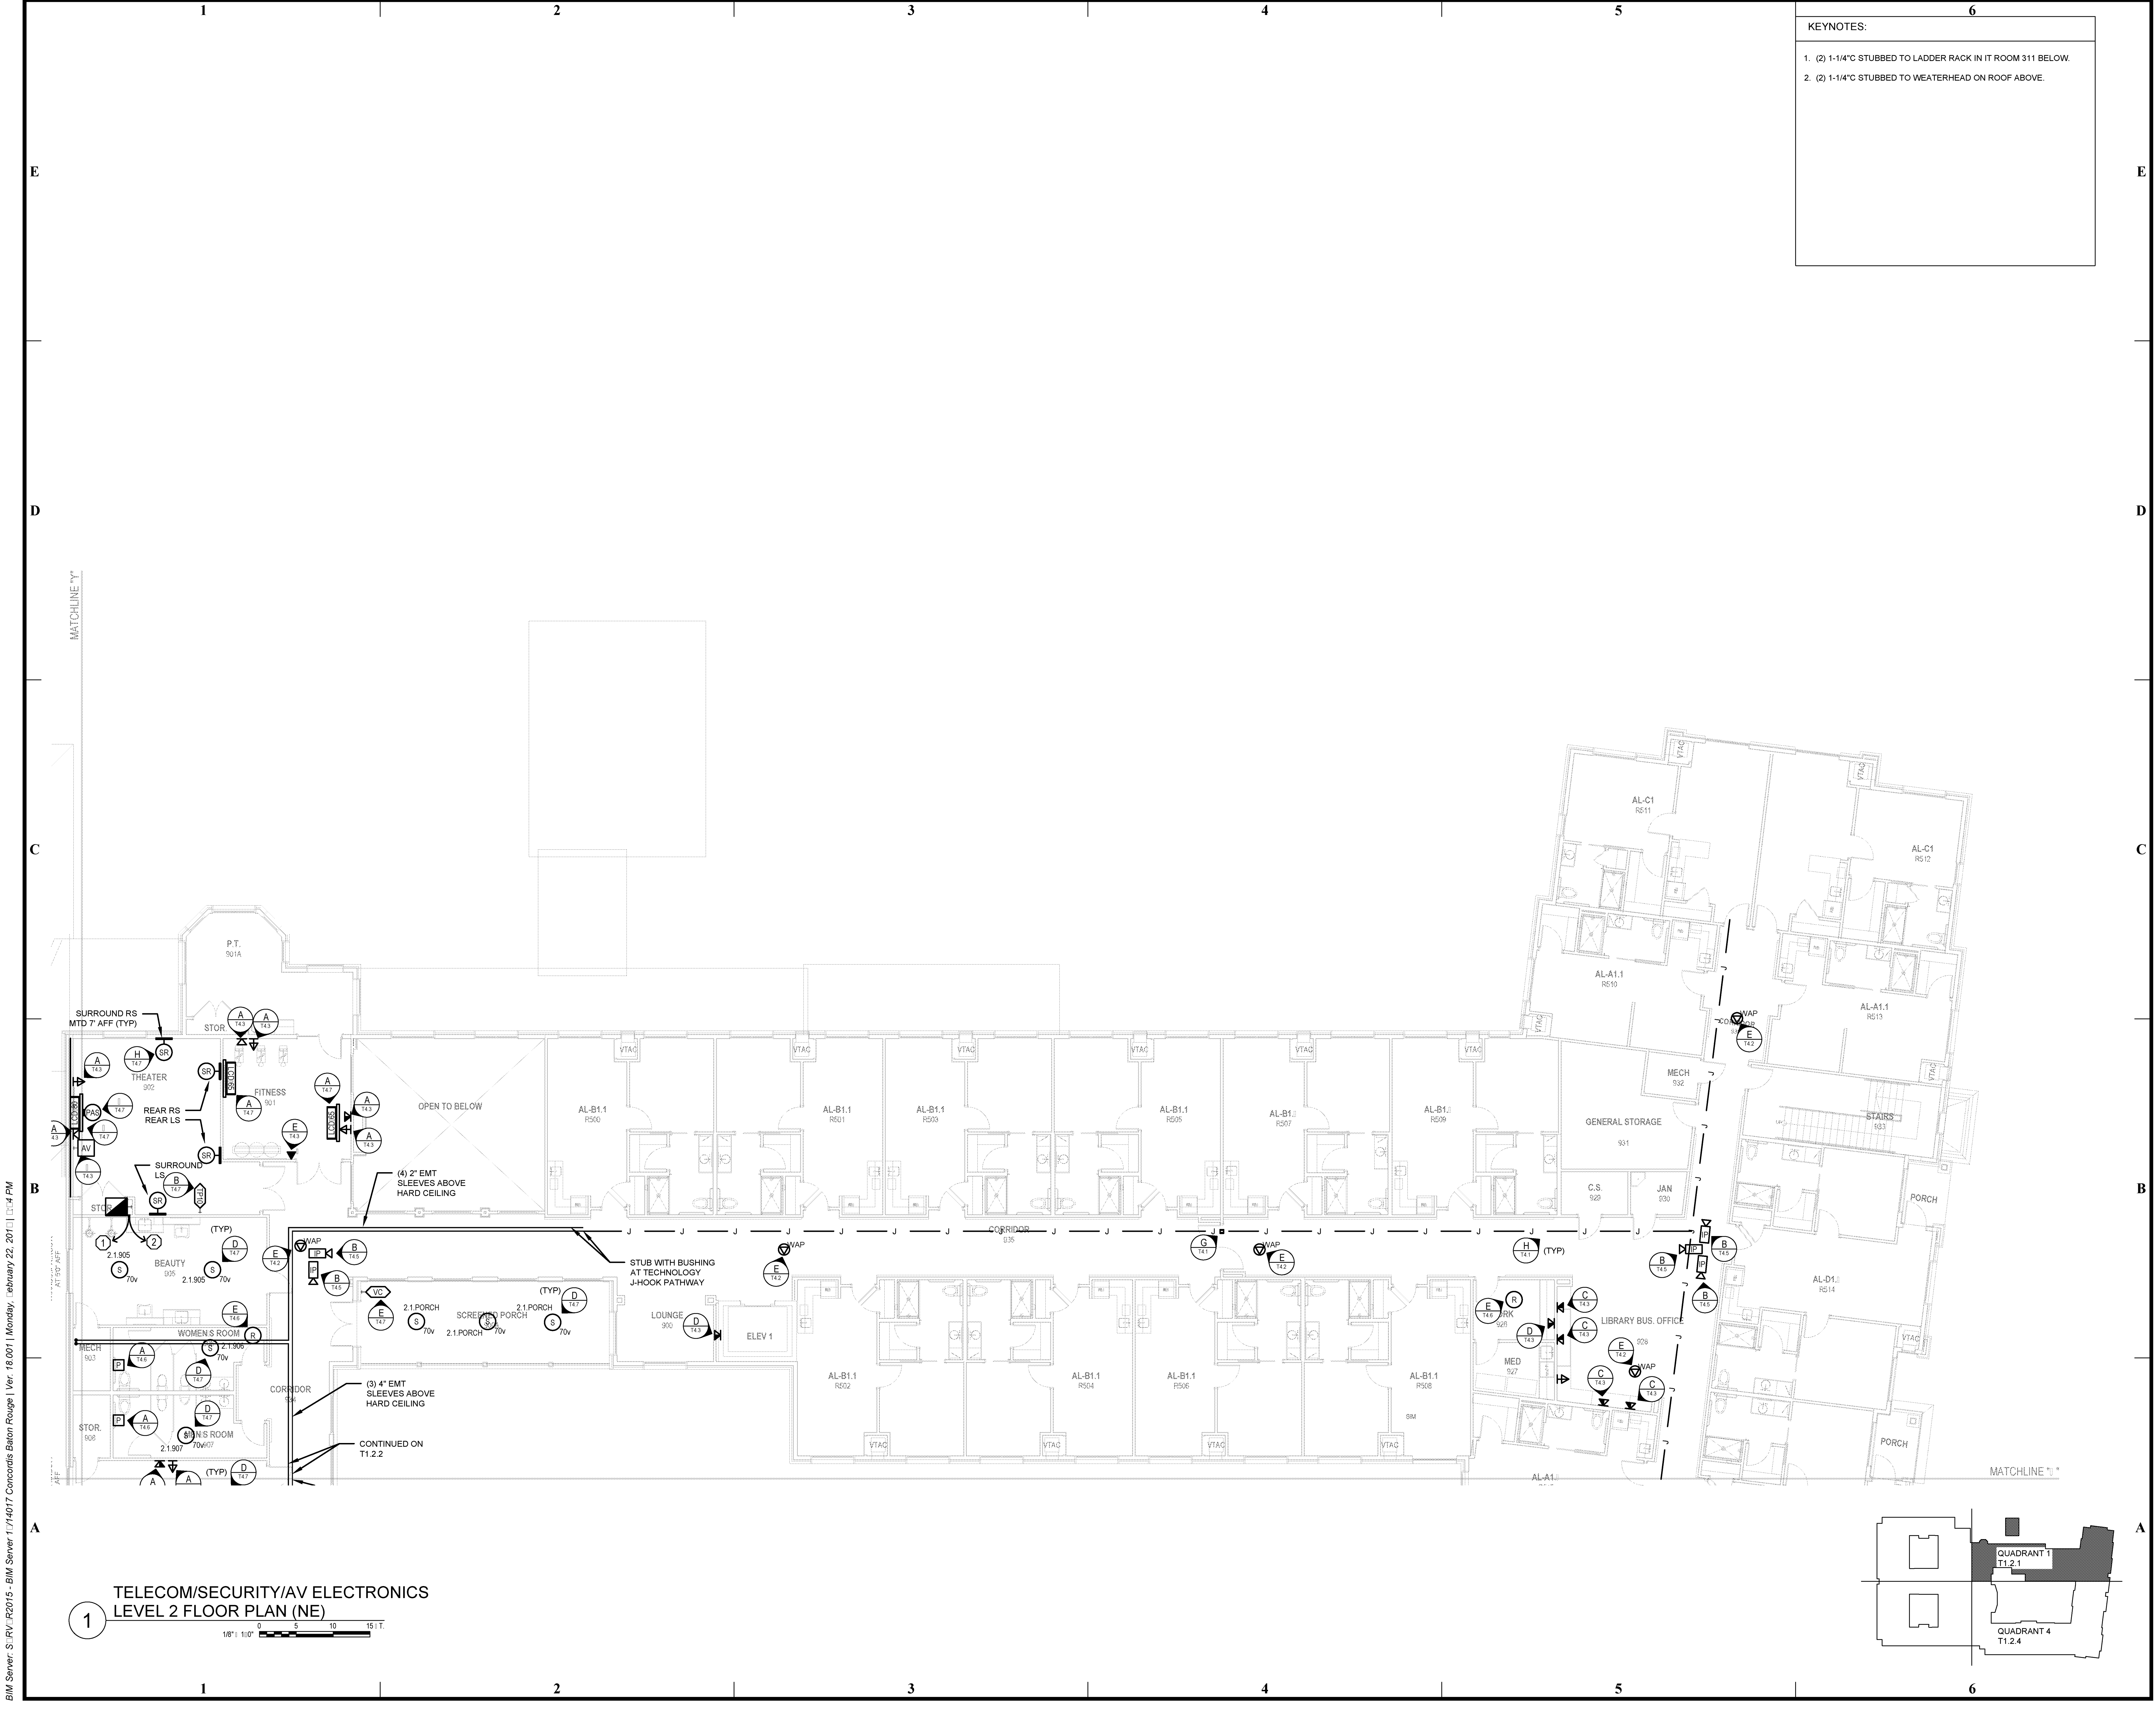

**1 TELECOM/SECURITY/AV ELECTRONICS
 LEVEL 2 FLOOR PLAN (NE)**

1/8" = 1'-0"

BIM Server: S:\RV\RV2015 - BIM Server\1\14017 Concordia Baton Rouge\Ver. 18.001\Monday, February 22, 2016 11:14 PM