


**WATERSTONE AT BATON ROUGE
 ASSISTED LIVING & MEMORY CARE**
 SIEGEN LANE
 BATON ROUGE, LA 70810

ISSUE: QA
 CONSTRUCTION
 DOCUMENTS



©2016 PI ARCHITECTS, INC.

REVISIONS:

DATE: 03/03/2016
 PROJECT NUMBER: 14017
 SHEET TITLE: TELECOM/SECURITY/AV ELECTRONICS LEVEL 2 FLOOR PLAN (SE)
 SHEET: T1.2.2

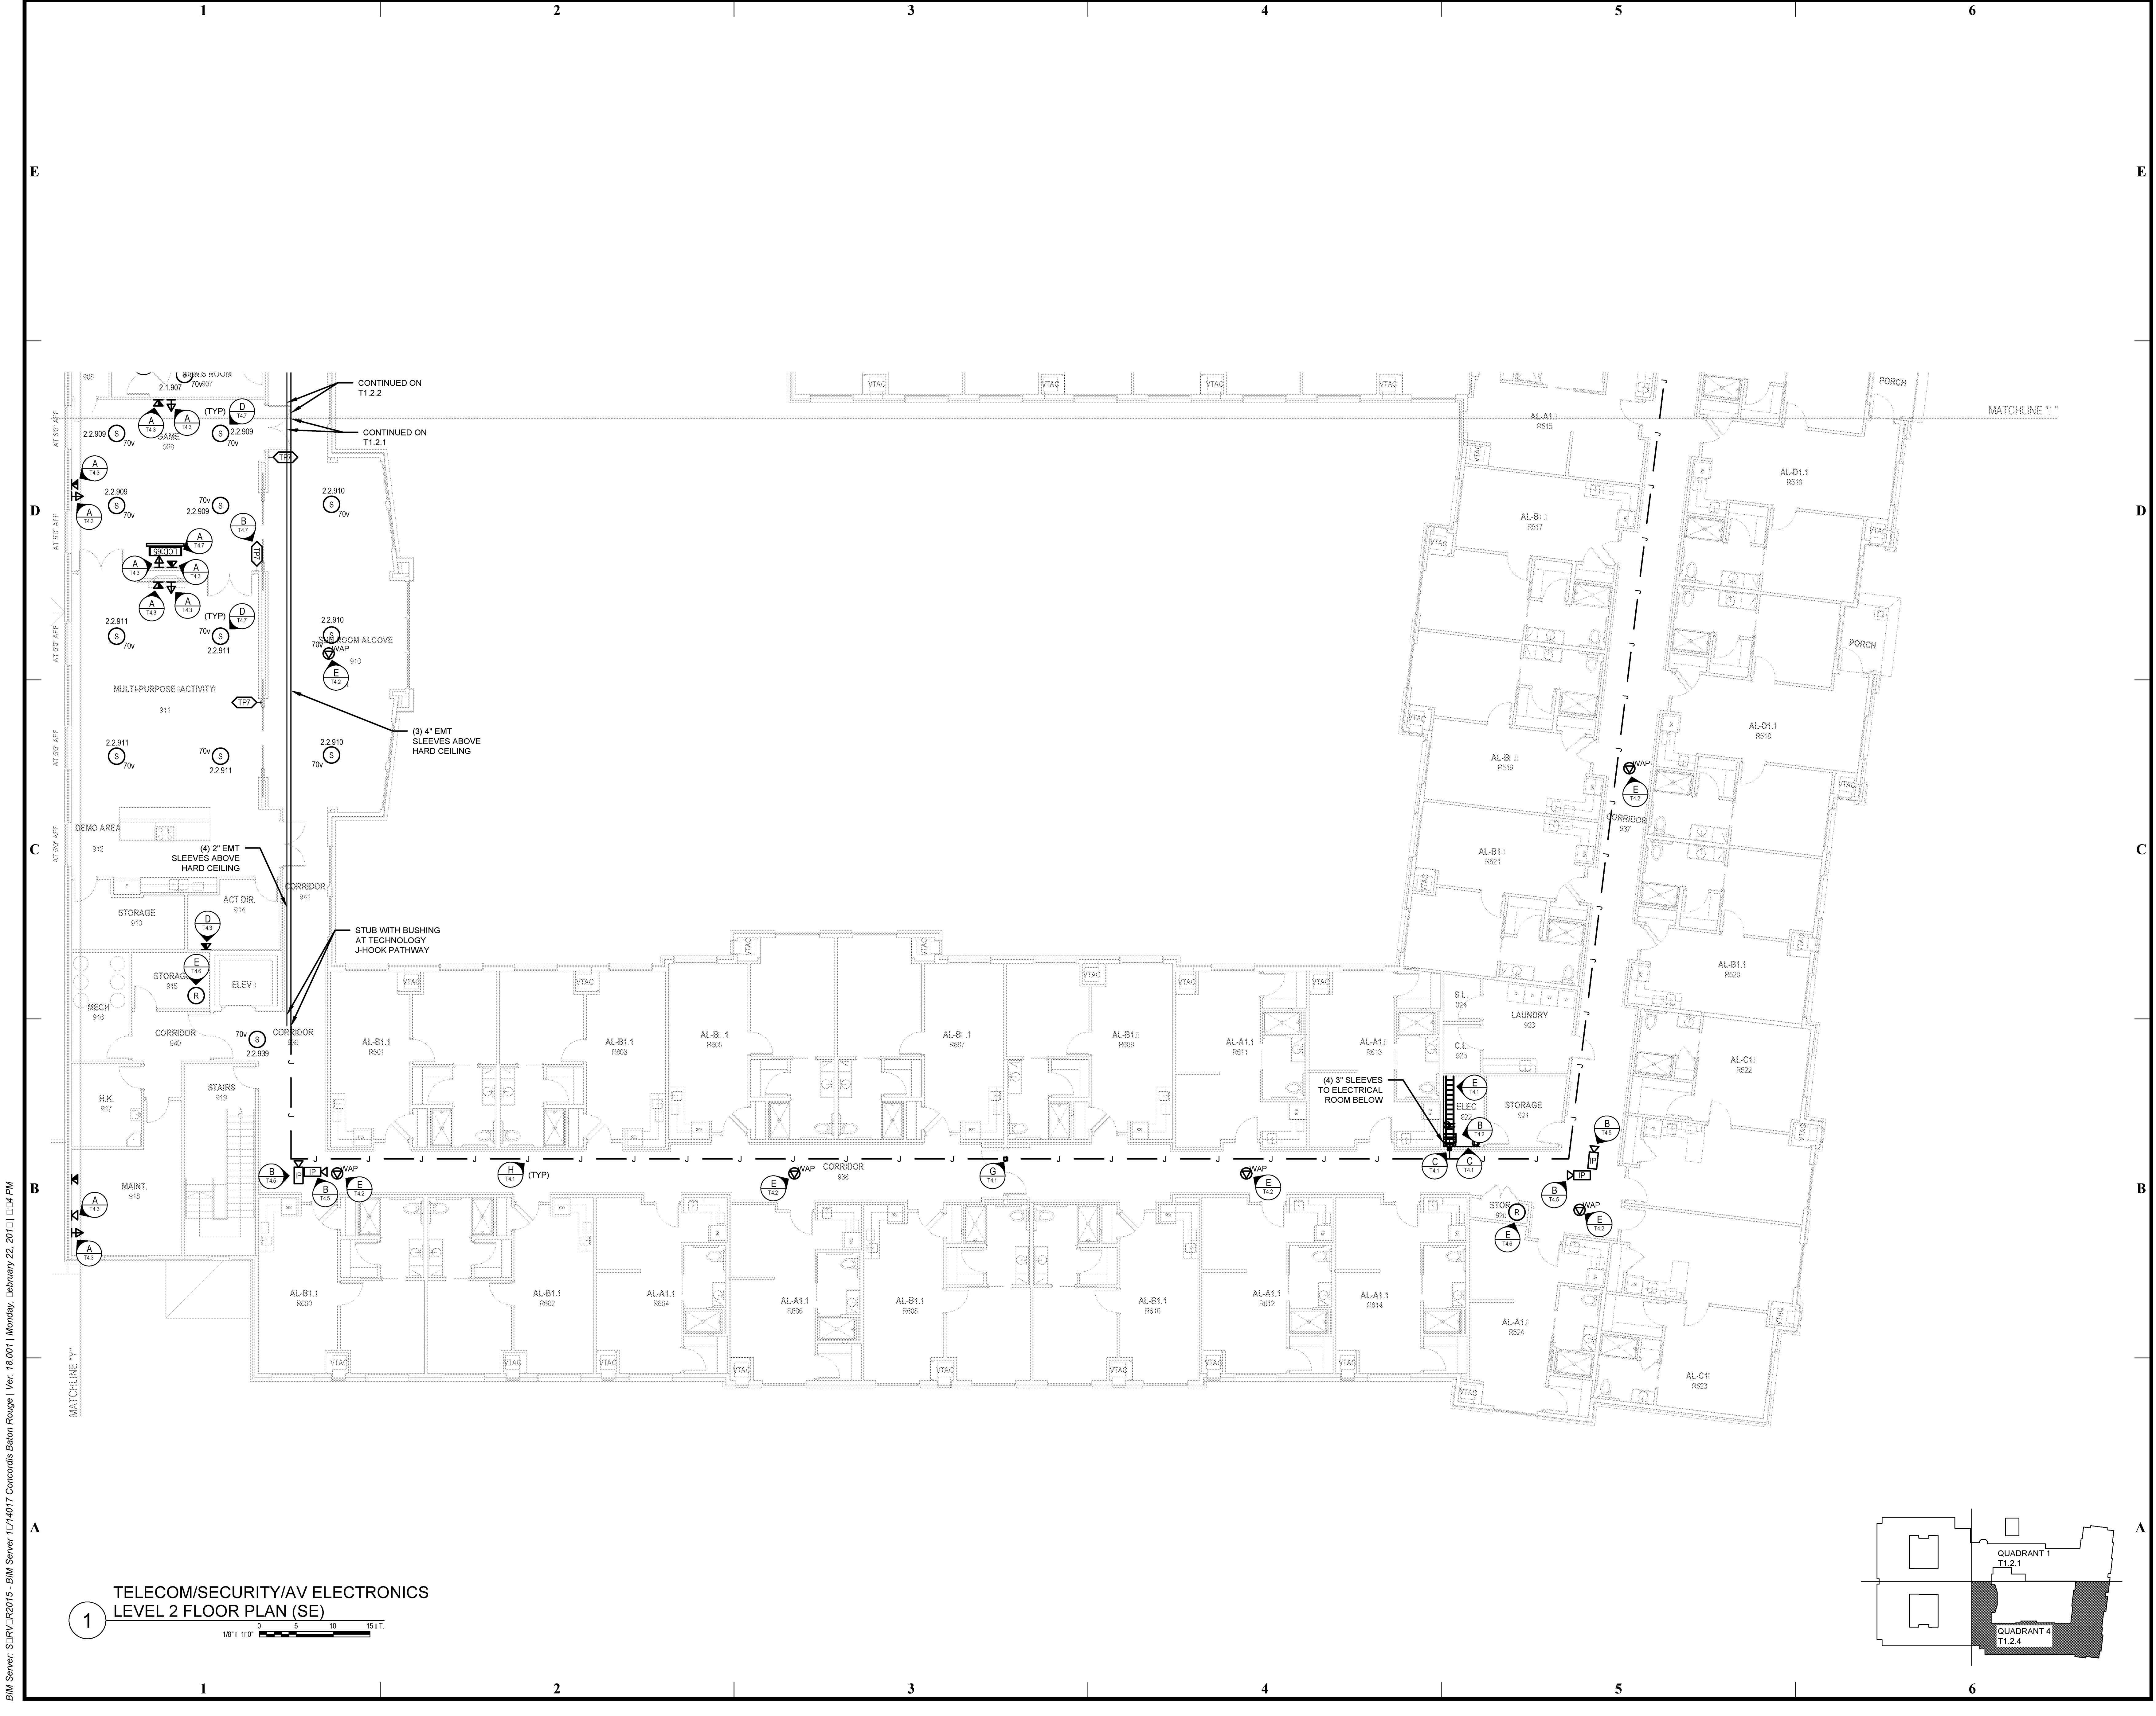

 **1 TELECOM/SECURITY/AV ELECTRONICS
 LEVEL 2 FLOOR PLAN (SE)**

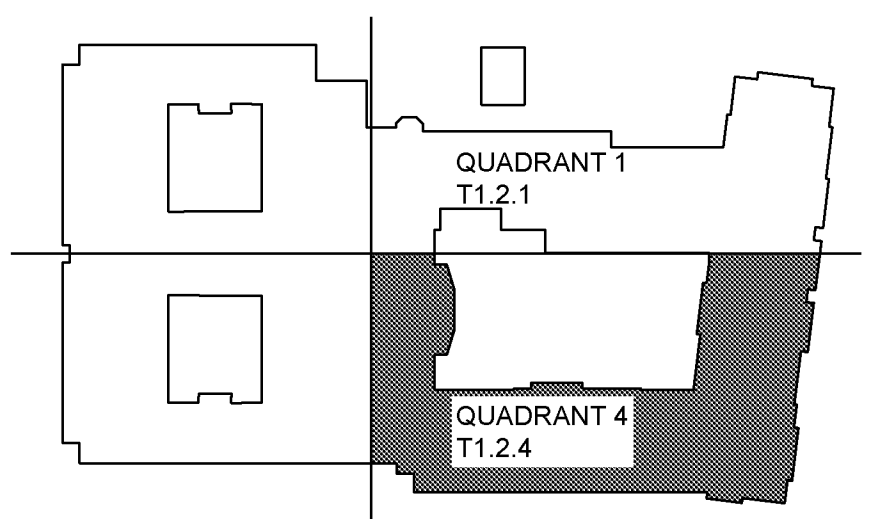

BIM Server: S:\RV\R2015 - BIM Server 1\14017 Concordia Baton Rouge\Ver. 18.001\Monday, February 22, 2016 11:14 PM