



pi architects
 3500 Jefferson St. Suite 303
 Austin, TX 78731
 P: (512) 231-1910
 F: (512) 231-1950
 www.piarch.com

architecture + master
 interior architecture

GUIDEPOST SOLUTIONS LLC
 2000 North Dallas Parkway, Suite 350
 Plano, TX 75063
 Office: (469) 956-2300
 Website: www.guidepostsolutions.com

WATERSTONE AT BATON ROUGE
ASSISTED LIVING & MEMORY CARE
 SIEGEN LANE
 BATON ROUGE, LA 70810

ISSUE:
 QA
 CONSTRUCTION
 DOCUMENTS


©2016 PI ARCHITECTS, INC.

REVISIONS:

DATE:
 03/03/2016
 PROJECT NUMBER:
 14017
 SHEET TITLE:
 TELECOM/SECURITY/AV
 ELECTRONICS
 DETAILS SHEET

SHEET:
T4.3

BIM Server: S:\V\F2015 - BIM Server\1714017 Concordia Baton Rouge | Ver: 18.001 | Monday, February 22, 2016 | 11:14 PM

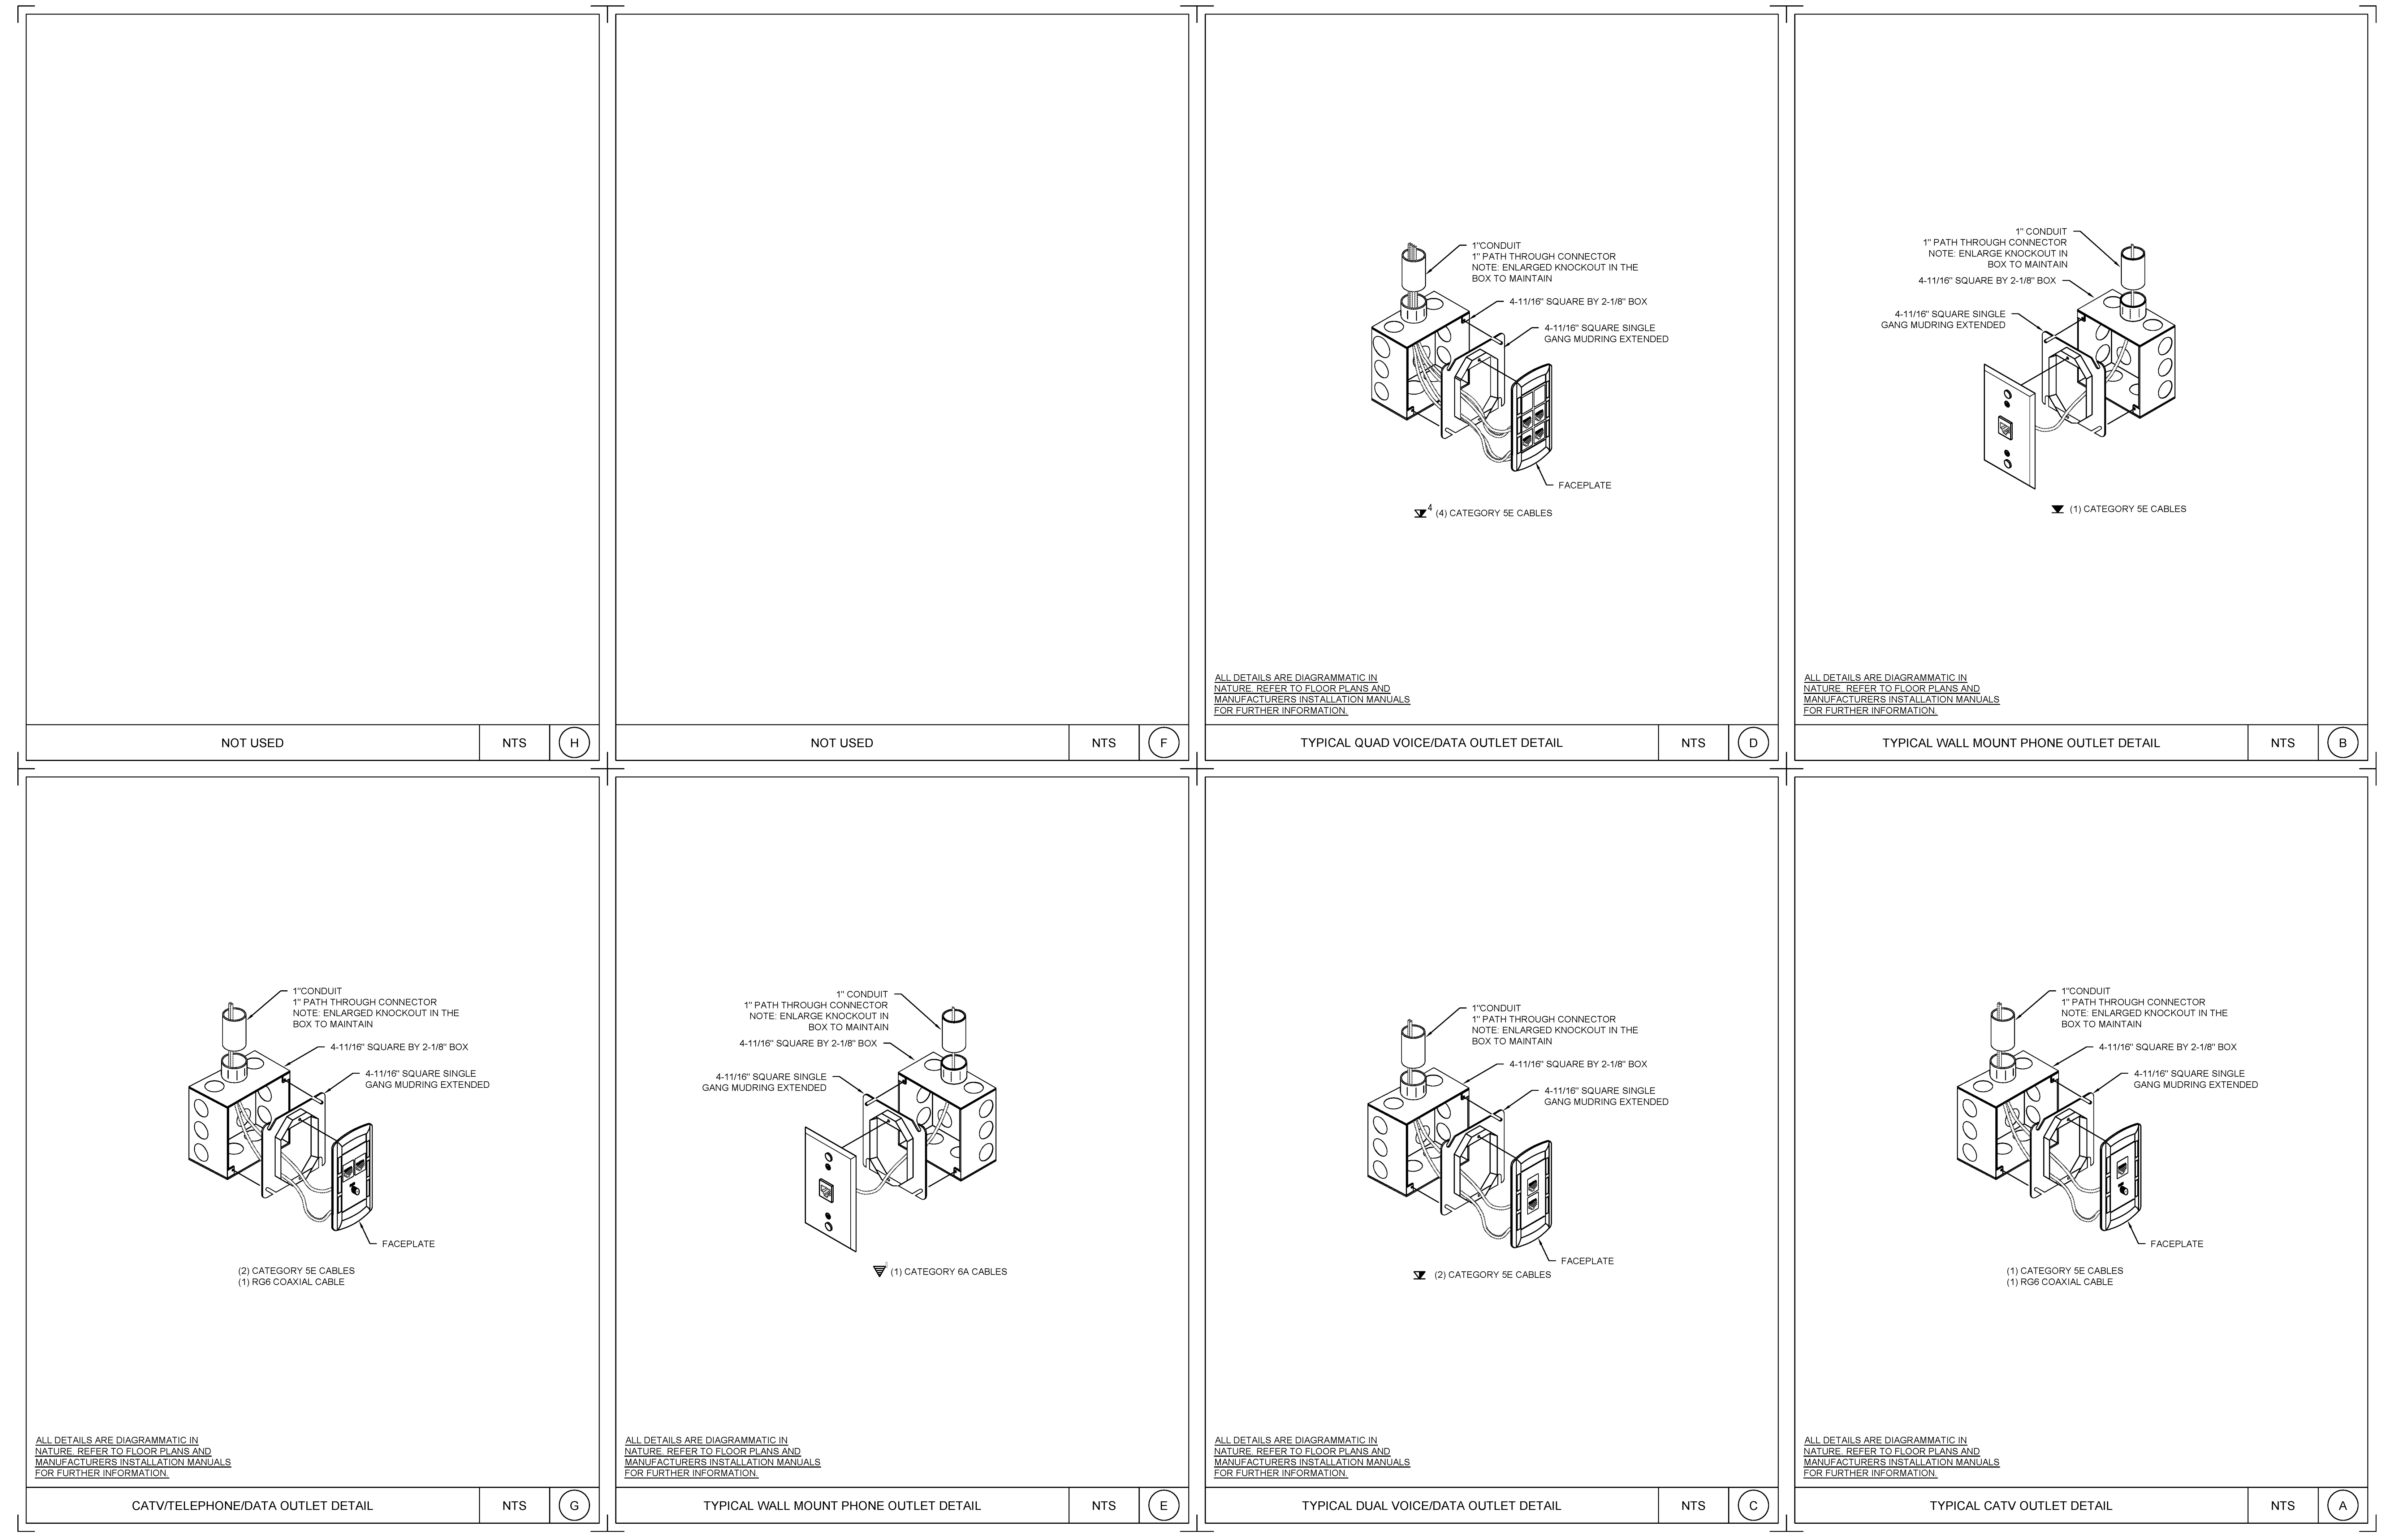

NOT USED NTS (H)

NOT USED NTS (F)

TYPICAL QUAD VOICE/DATA OUTLET DETAIL NTS (D)

TYPICAL WALL MOUNT PHONE OUTLET DETAIL NTS (B)

CATV/TELEPHONE/DATA OUTLET DETAIL NTS (G)

TYPICAL WALL MOUNT PHONE OUTLET DETAIL NTS (E)

TYPICAL DUAL VOICE/DATA OUTLET DETAIL NTS (C)

TYPICAL CATV OUTLET DETAIL NTS (A)

ALL DETAILS ARE DIAGRAMMATIC IN NATURE. REFER TO FLOOR PLANS AND MANUFACTURERS INSTALLATION MANUALS FOR FURTHER INFORMATION.

ALL DETAILS ARE DIAGRAMMATIC IN NATURE. REFER TO FLOOR PLANS AND MANUFACTURERS INSTALLATION MANUALS FOR FURTHER INFORMATION.

ALL DETAILS ARE DIAGRAMMATIC IN NATURE. REFER TO FLOOR PLANS AND MANUFACTURERS INSTALLATION MANUALS FOR FURTHER INFORMATION.

ALL DETAILS ARE DIAGRAMMATIC IN NATURE. REFER TO FLOOR PLANS AND MANUFACTURERS INSTALLATION MANUALS FOR FURTHER INFORMATION.